


SCHEMATIC SINGLE LINE DIAGRAM

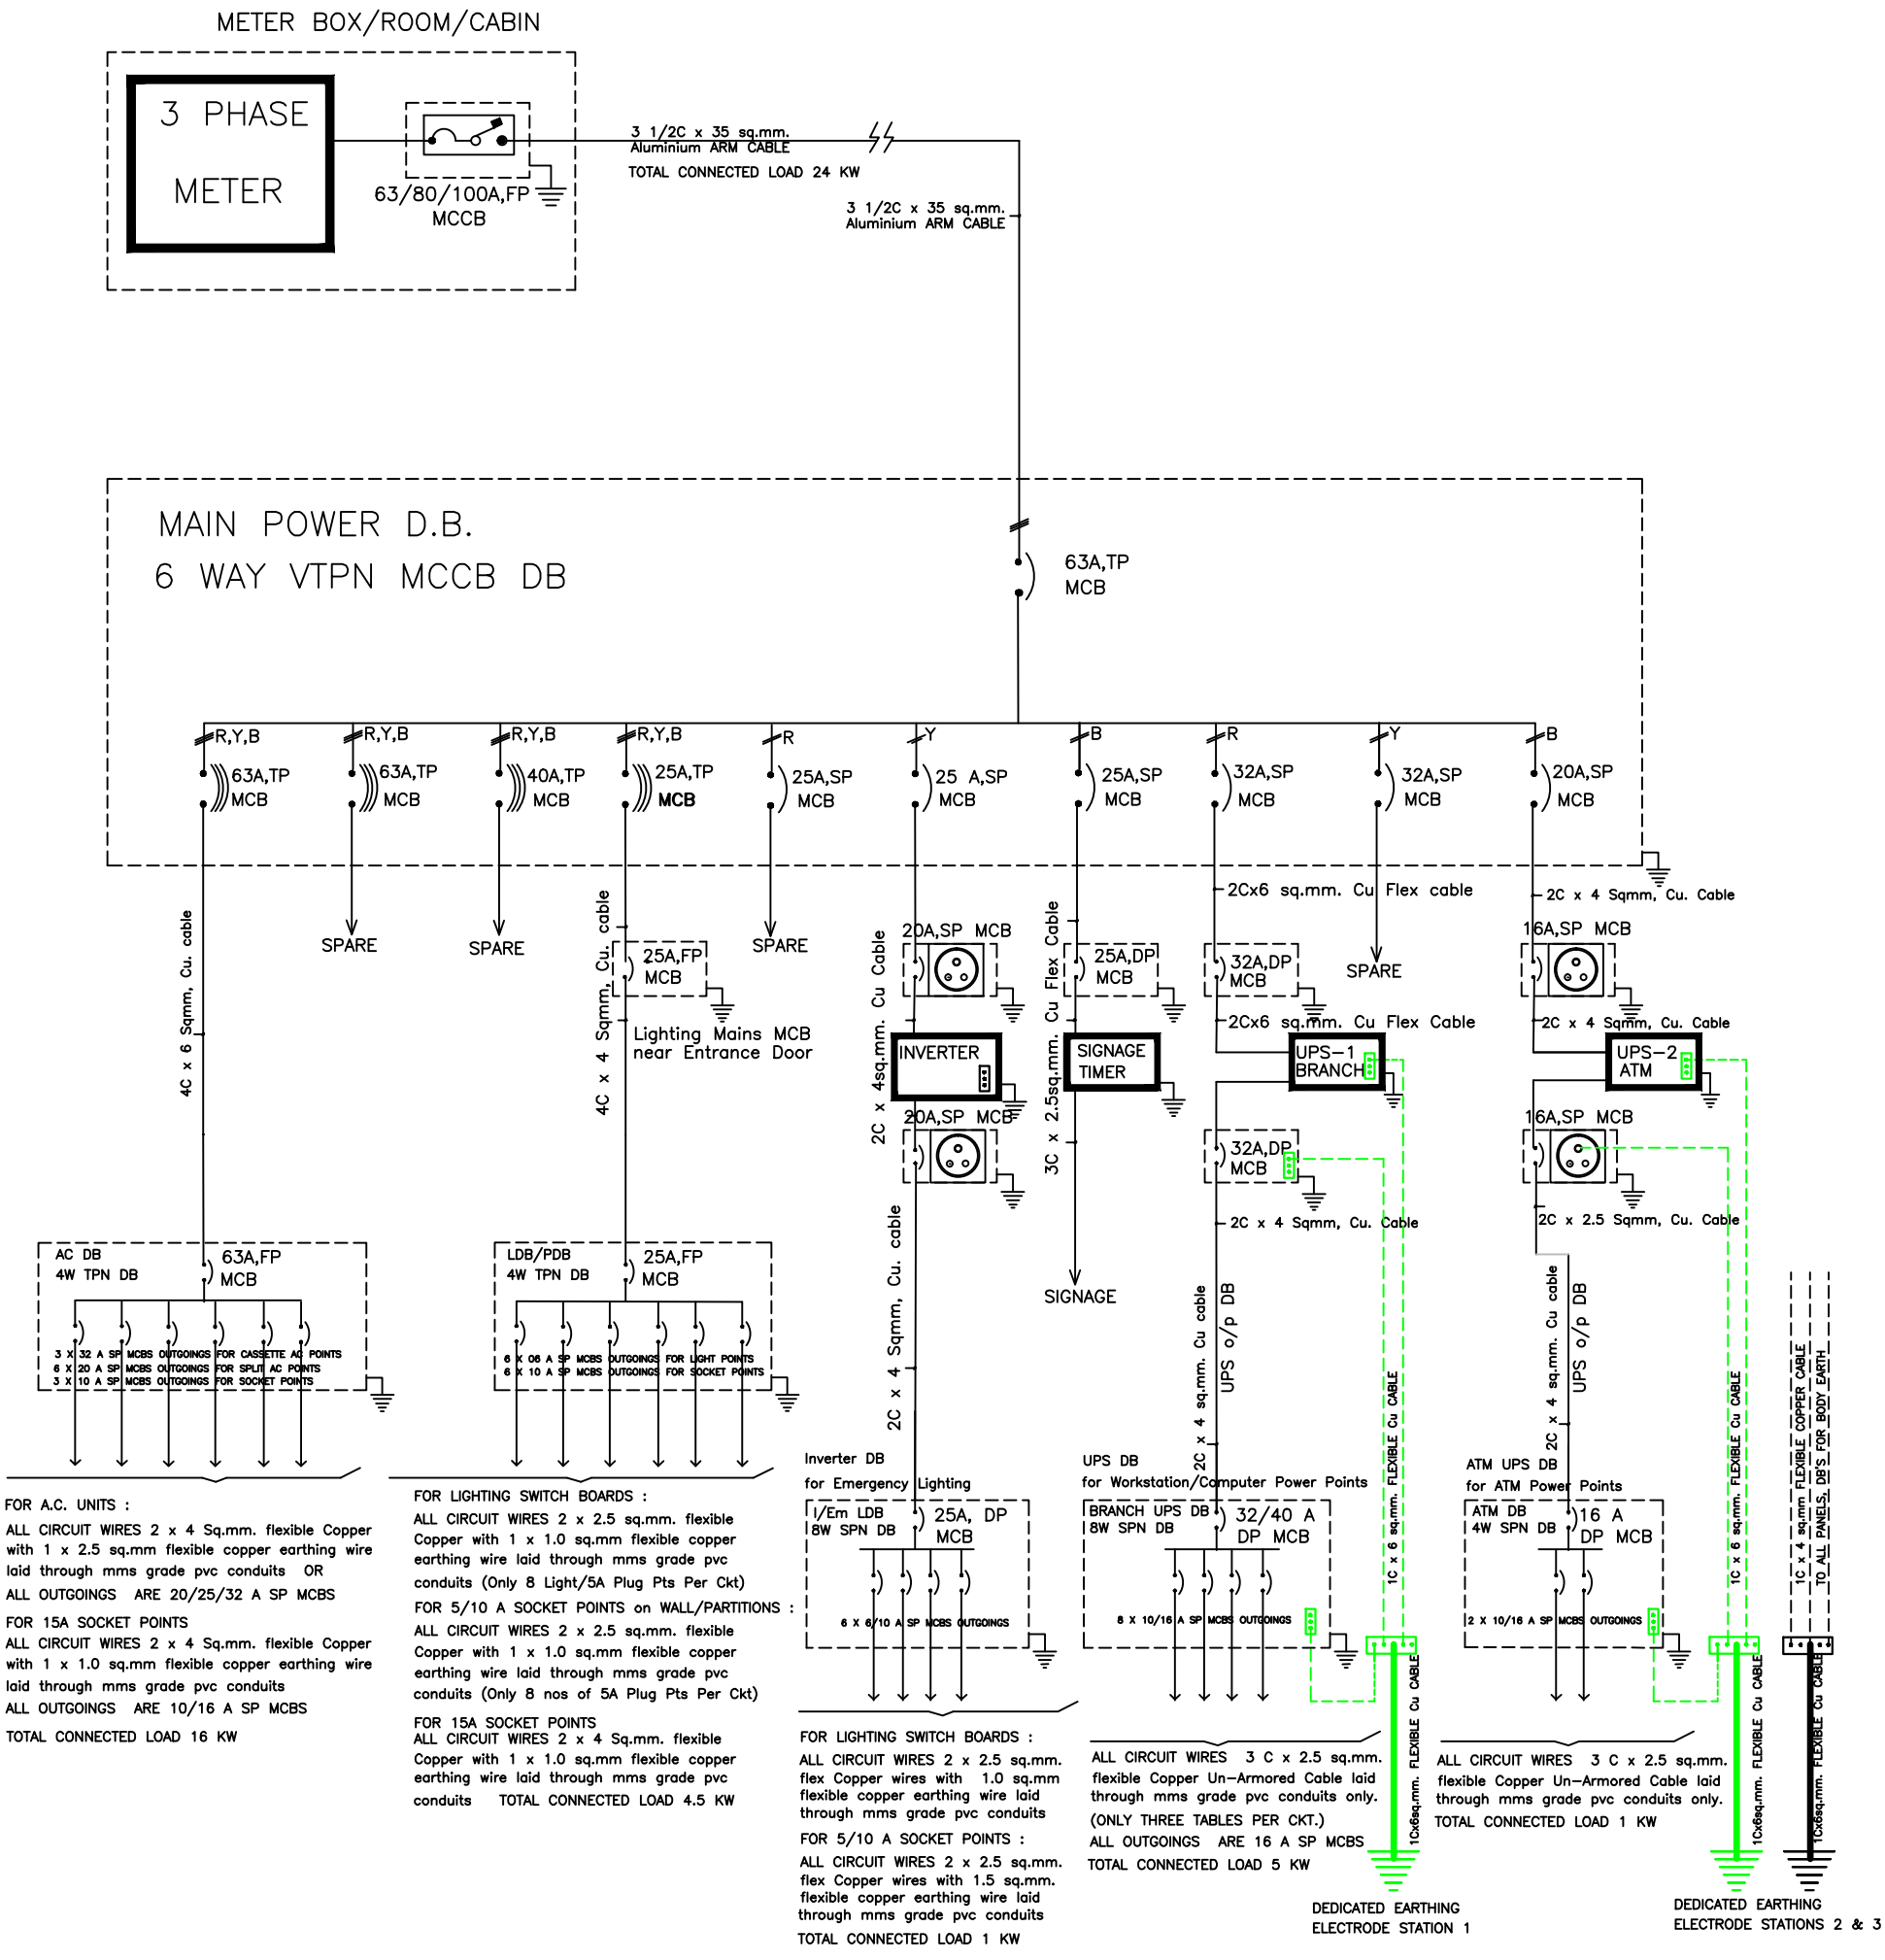

Client : CANARA BANK

Project : CANARA BANK, BAVDHAN BRANCH, PUNE

Architect :
NARENDRA SARDESHPANDE & ASSOCIATES
43, Shreekul, Flat no 2, Ground Floor,
United Western Housing Society,
Near Tathwade Garden, Karvenagar, Pune - 411
Contact : 9822072016, (020) 25454297

Electrical Consultant :
Jayesh Rao
A-2 / 201-202, Om Shiv CHS Ltd,
Ghodbandar Road, near R-Mall,
Thane (w), Maharashtra - 400607.
Mb.: 9821232350, E-mail : rao_jayesh@rediffmail.com

Scale : Drawn :

Date : 01 - 02 - 2024 Chkd :

Title : ELECTRICAL S. L. D. LAYOUT

Drg No.: Rev. : 03