



NAGULAPALEM BRANCH

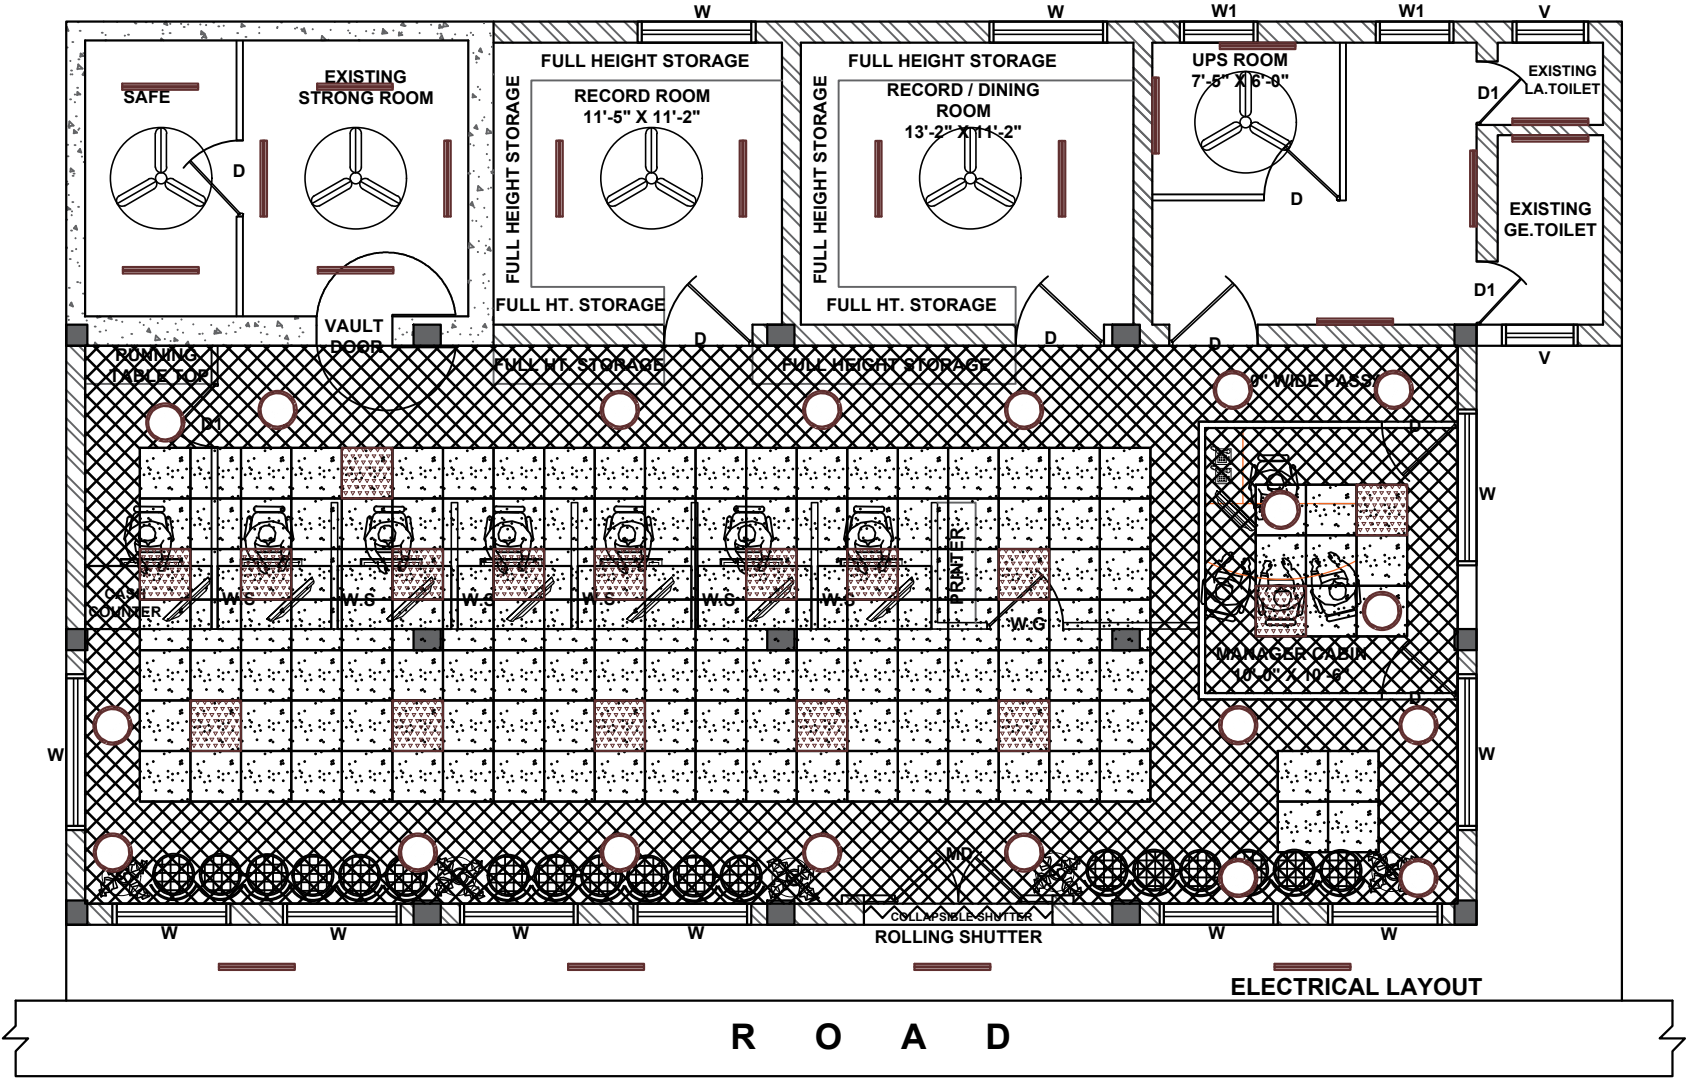

- DOWN LIGHT
- 2' X 2' LIGHT
- 4' LED LIGHT
- GYPSUM
- 2' X 2' MINERAL FIBRE TILE
- CEILING FAN

PROJECT:
 PROPOSED INTERIOR PROJECT FOR CANARA BANK
 NAGULAPALEM BRANCH AT NAGULAPALEM, PRAKASAM DIST.

 TITLE:-
 ELECTRICAL LAYOUT



SCALE:
 N.T.S
DATE:
 03/12/2024

DRAWN:-
 VISHNU VARDHAN
CHECKED:
 SHYAM RAJ

SRR Architechniques
 Architects, Planners & Engineers
 Address:
 Jayaram, 6th Floor, Gokul Kalyan Apartments, Street No. 1, Himmavaram,
 Jagadamba Nagar, Mysuru
 813 9999999