


LEGEND

SN.	SYMBOL	DESCRIPTION	nos.
1		600X600 LIGHT	09
2		DOWN LIGHTER	24
3		BATTEN LIGHT	04
4		STRIP LIGHT	30M

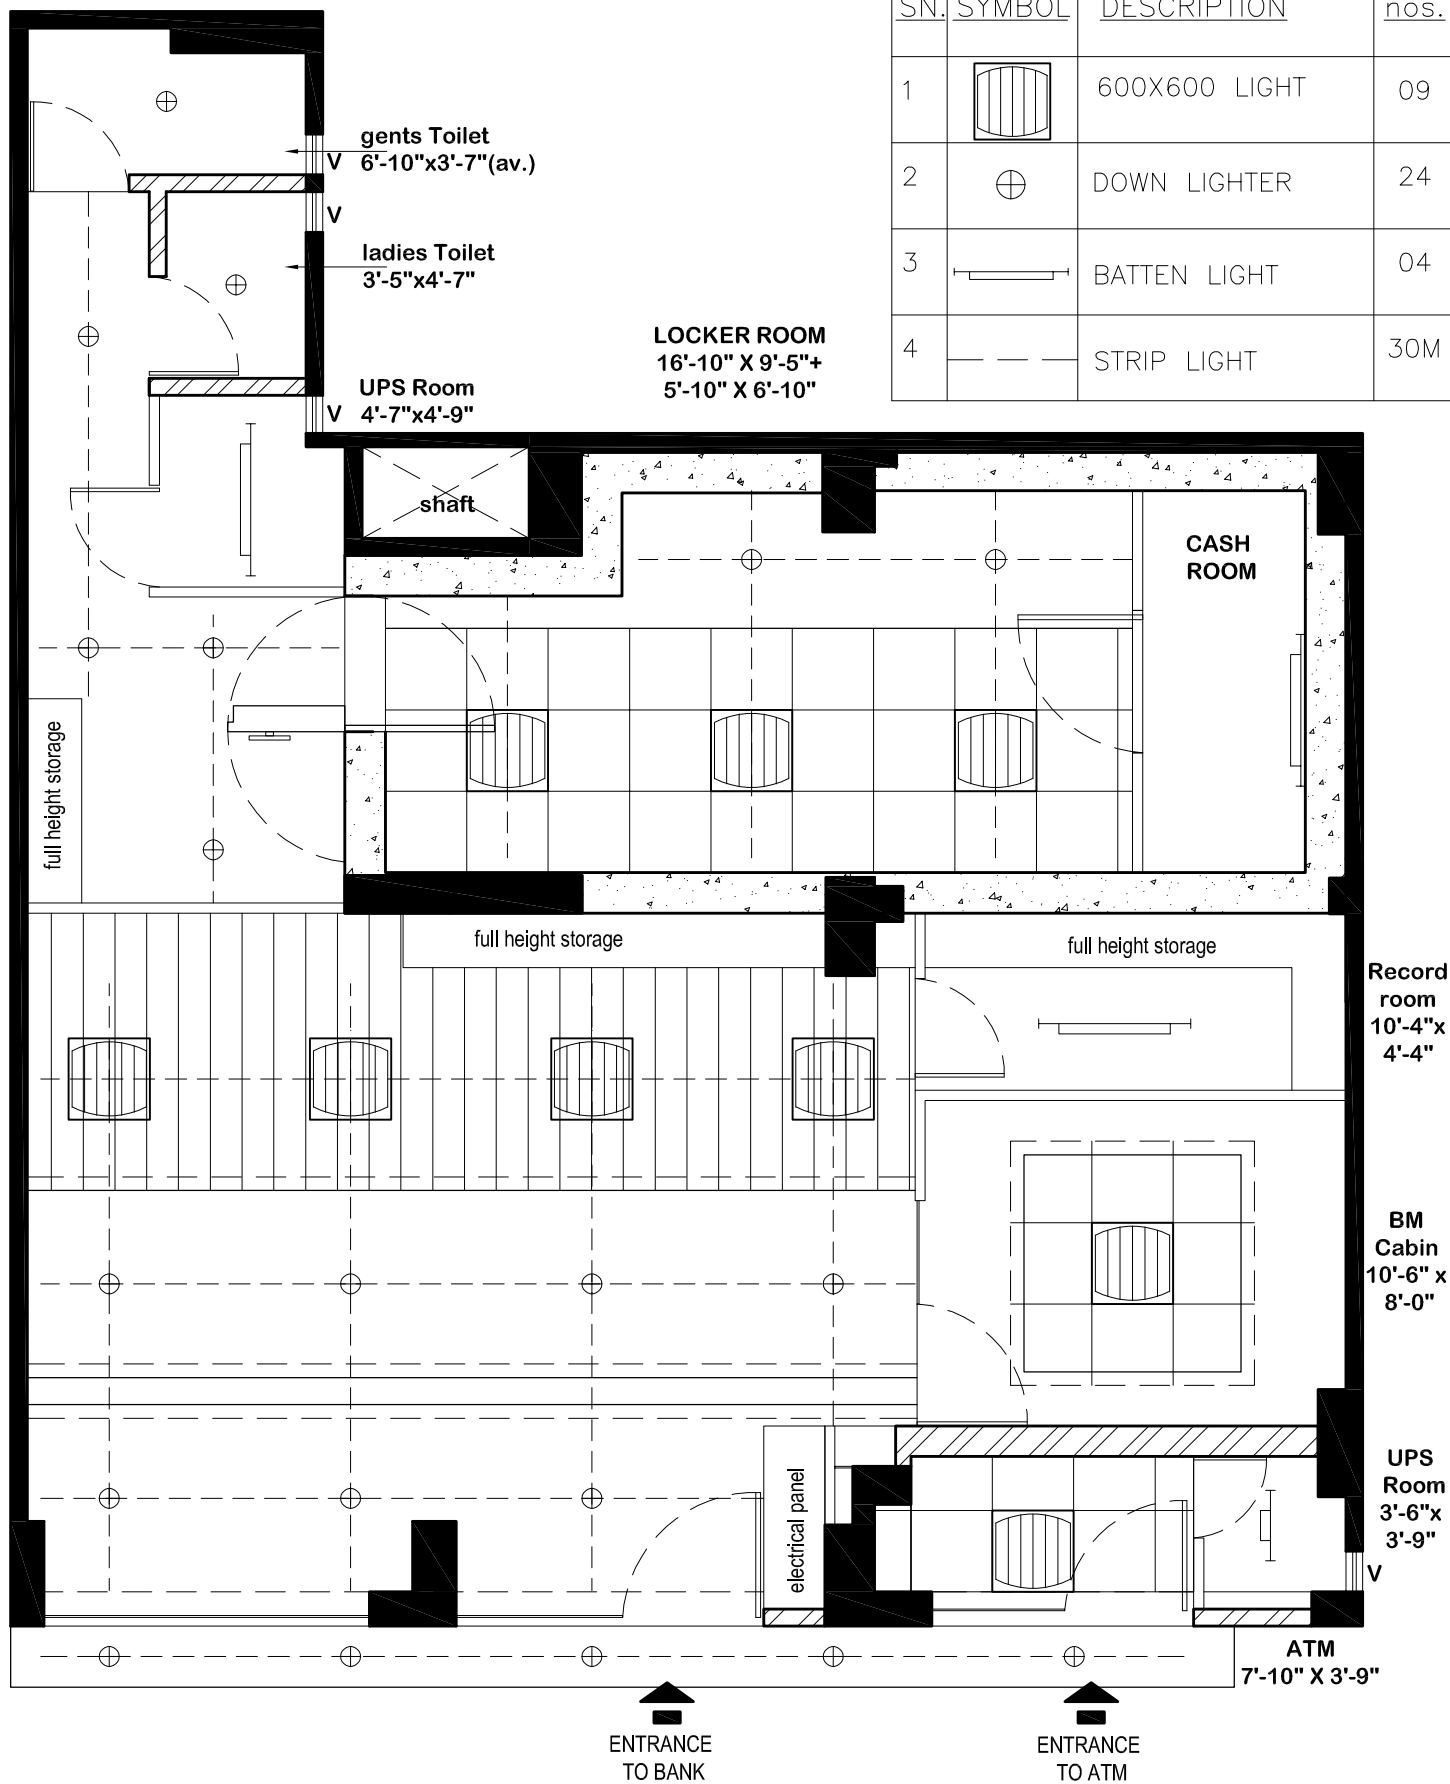

CANARA BANK
SECTOR - 75 BRANCH,
NOIDA

Drawing Title:
LIGHTING PLAN

Date:
02/09/2024

Drawing No.:
CN/MG/AD/01

GEOTECH TECHNICAL ASSOCIATES
G T A

B-004, Amrapali Princely Estate, Sector - 76, Noida - 201301
ph.: 9818938150, 9910297218
e-mail: technicalassociates9@gmail.com