


ROAD

WARDHANNAPETA BRANCH

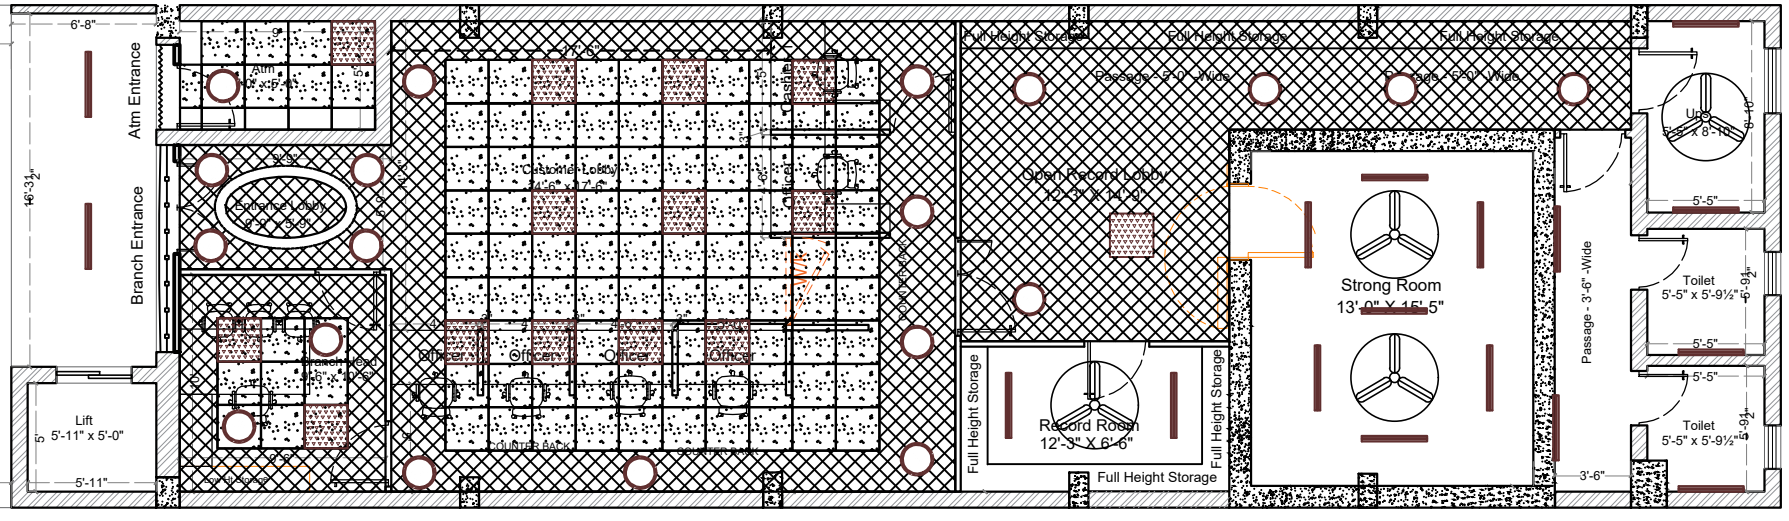

PROJECT:-

PROPOSED INTERIOR PROJECT FOR CANARA BANK
WARDHANNAPETA BRANCH AT WARDHANNAPETA, WARANGAL DIST.

TITLE:-

ELECTRICAL LAYOUT

Sign:



SCALE:-

N.T.S

DATE:-

16/09/2024

DRAWN:-

J. SHYAM RAJ

DEALT:-

S RAGHURAM



SRR Architechniques
Architects, Planners & Engineers

Address: 2-4-20152, Gokul Park Apartments, Street No. 10, Huzurpeta, Warangal, Telangana - 506009
Phone: 9490000000