


LEGEND

S.No.	SYMBOL	DESCRIPTION	Nos.
1		DOWN LIGHTER	36
2		T- 5	15
3		600X600 DOWN LIGHT	16
4		T- 5	04

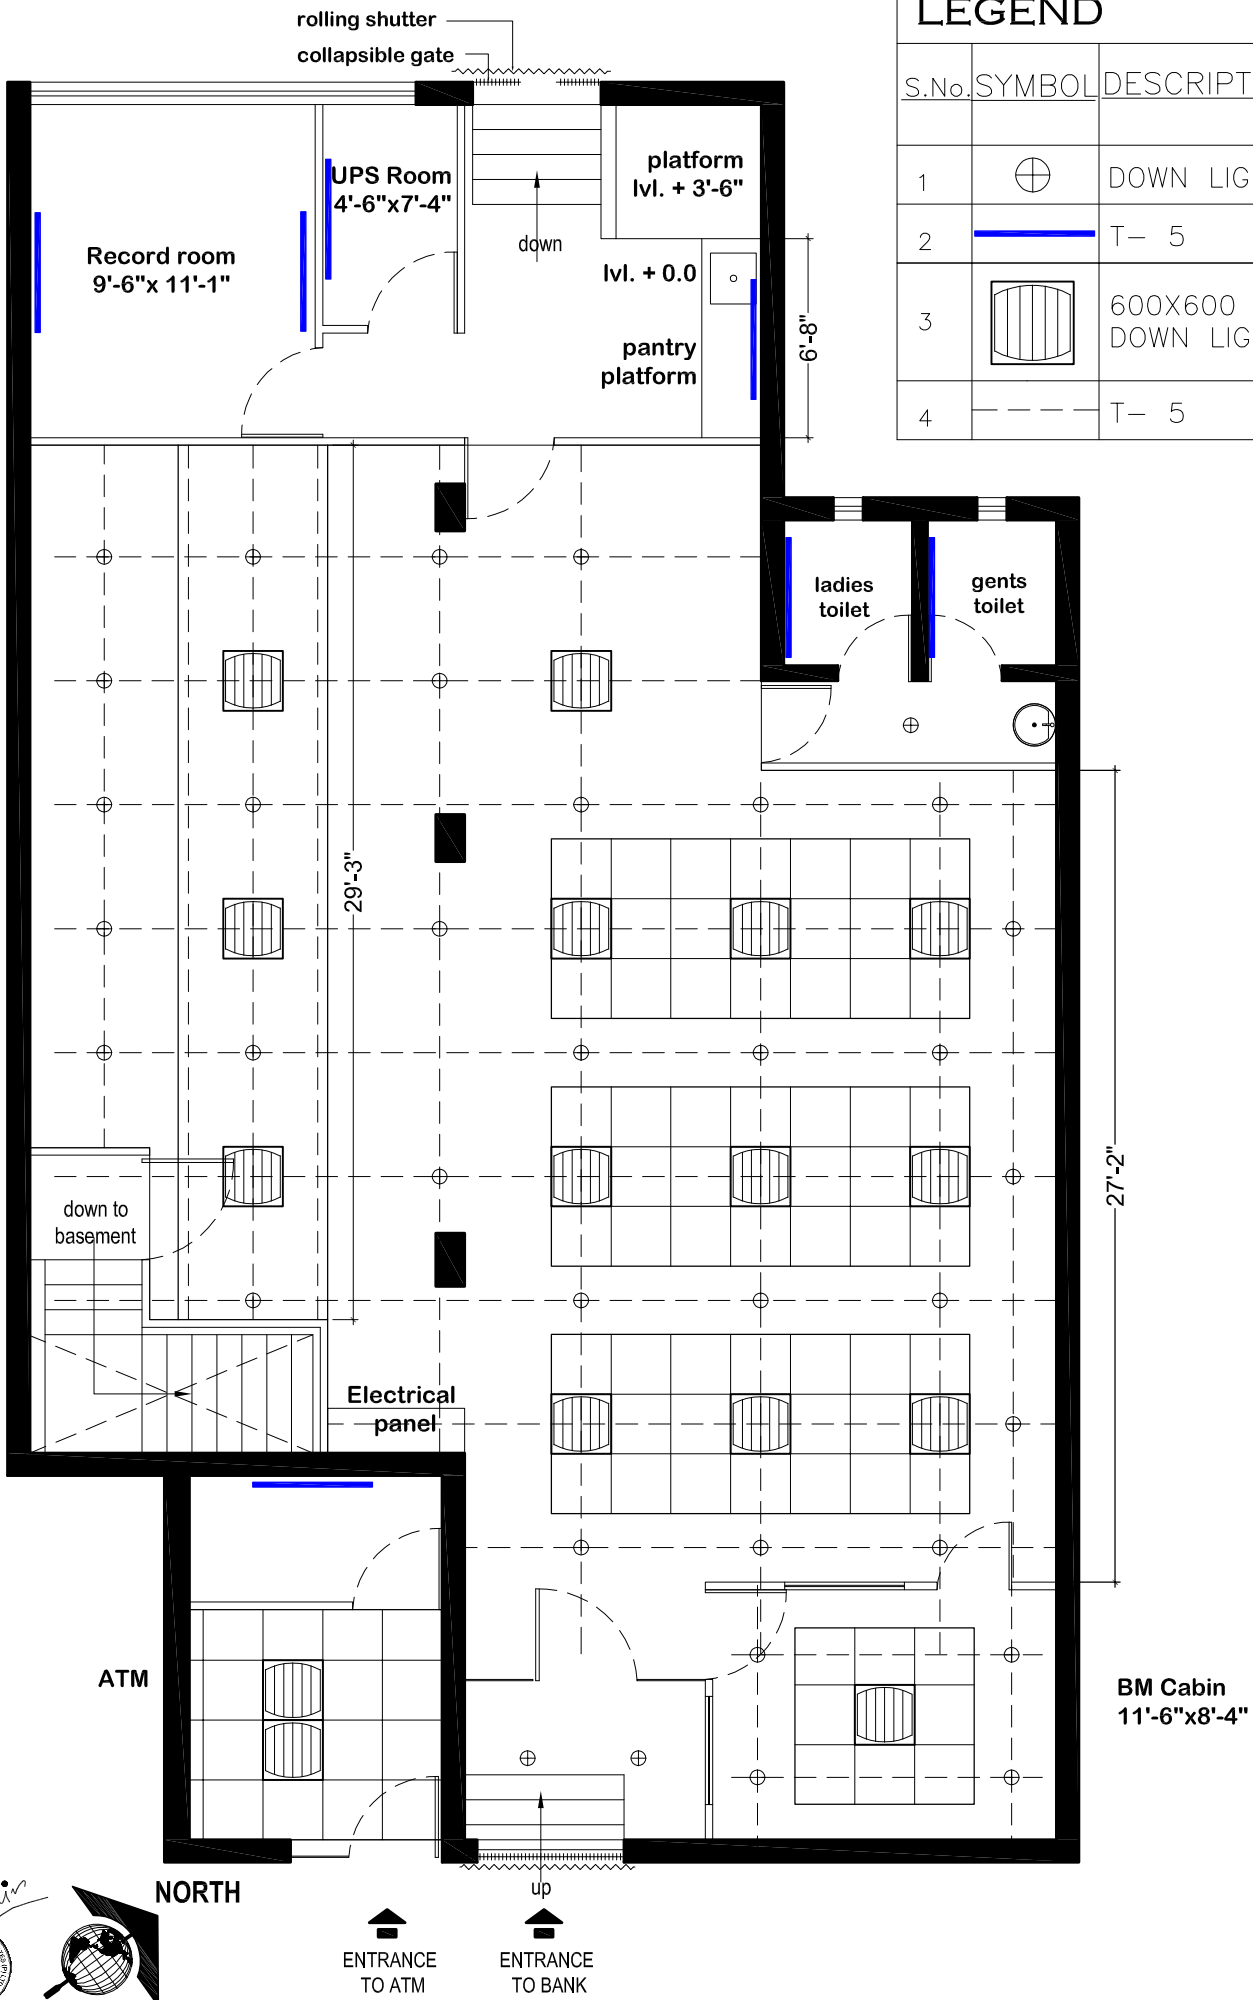

ENTRANCE TO ATM

ENTRANCE TO BANK

CANARA BANK
SECTOR 10A BRANCH,
GURUGRAM

Drawing Title:
LIGHTING PLAN- GROUND FLOOR

Date:
07/05/2024

Drawing No. :
CN/NO/AD/02

GEOTECH TECHNICAL ASSOCIATES (P) LTD.
G T A

B-004, Anrapalli Princely Estate, Sector - 76, Noida - 201301
ph.: 9818938150, 9910297218
e-mail : technicalassociates9@gmail.com