


24 HP 22 HP

OUTDOOR UNIT TO BE PLACED ON TERRACE, ONE FLOOR ABOVE

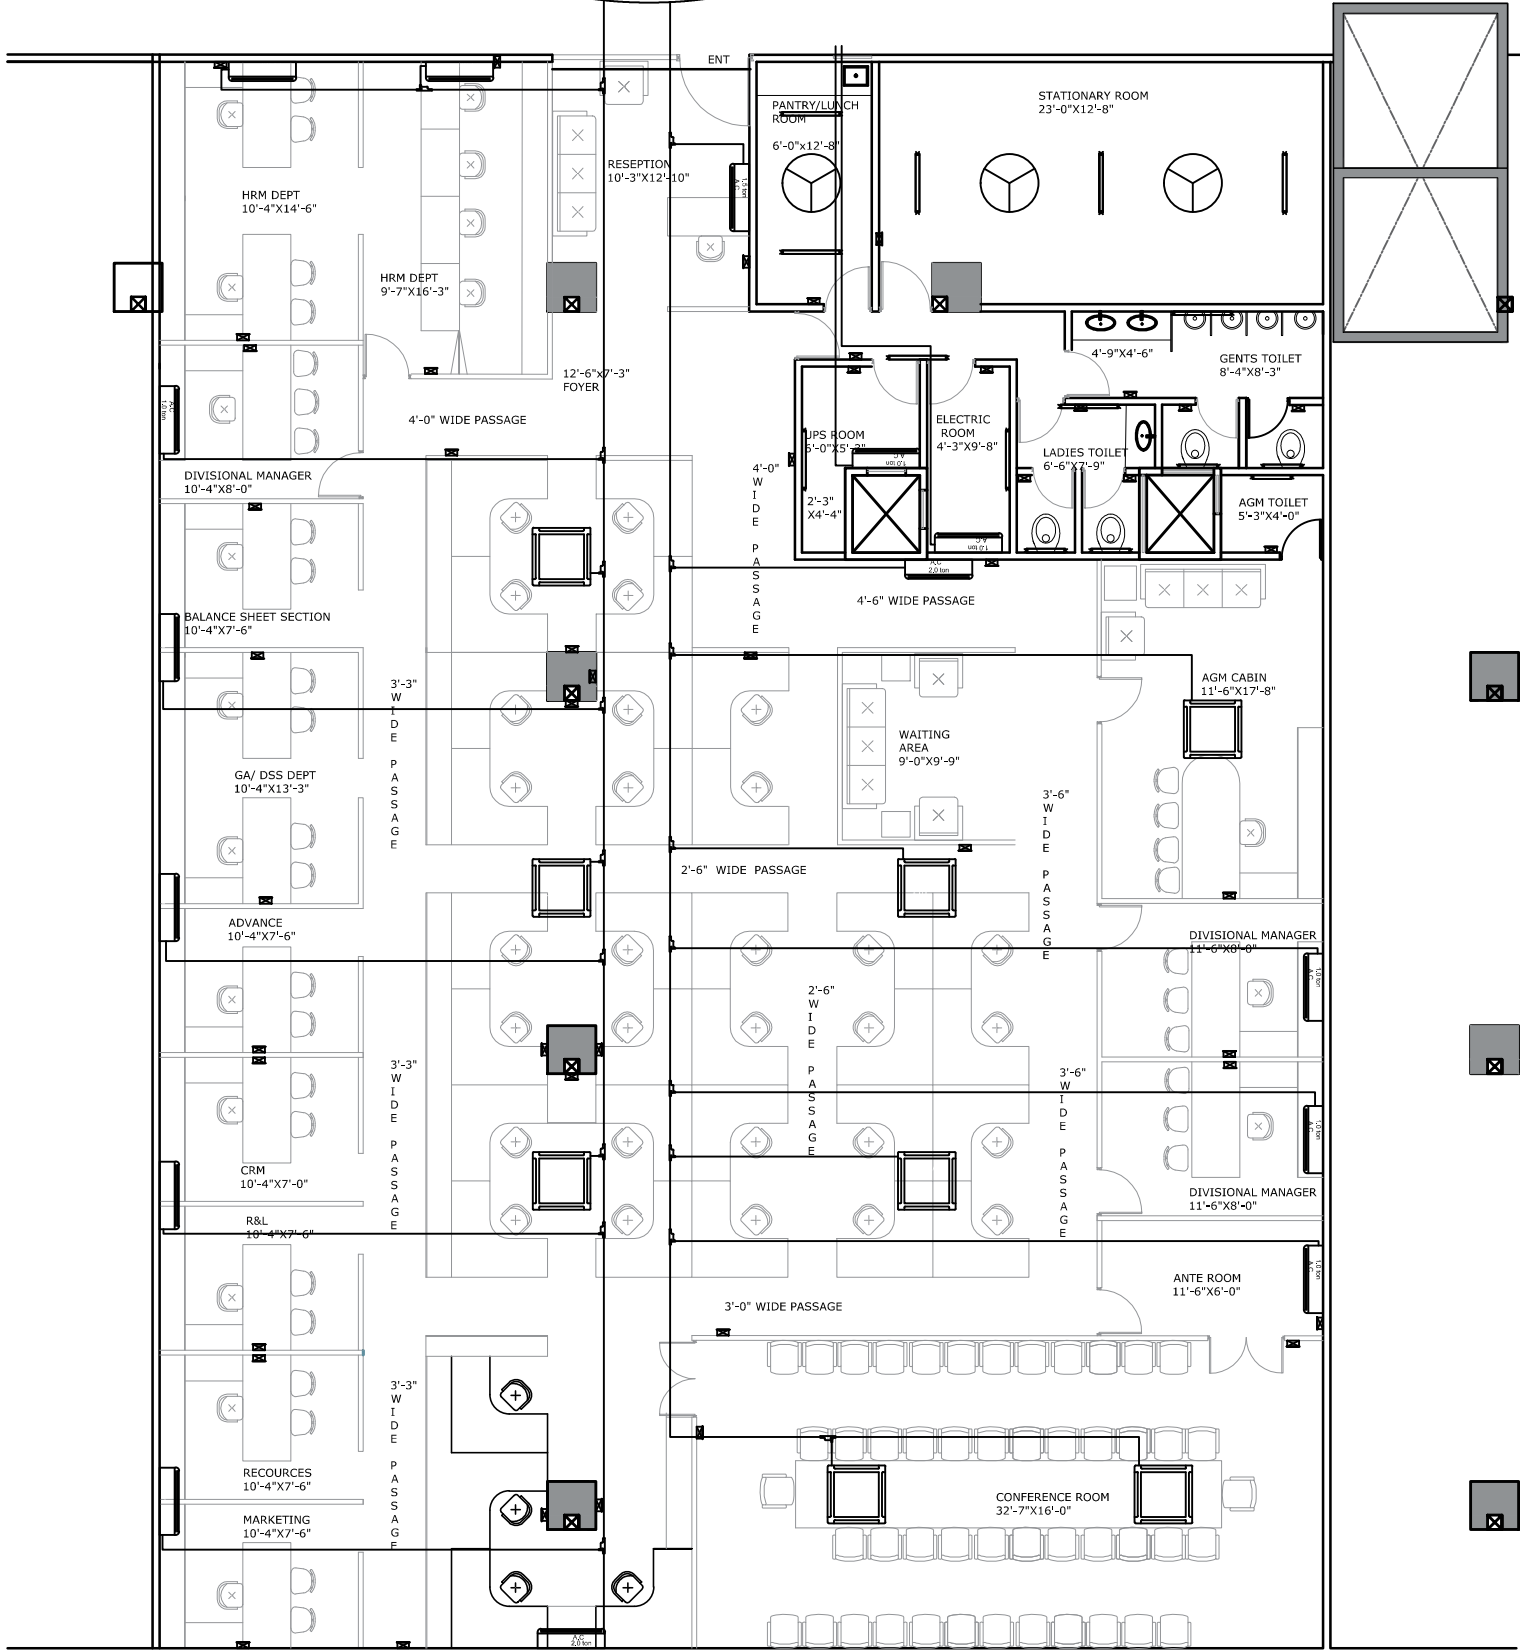

ALT.NO:02/R2

PROJECT TITLE:  
CANARA BANK RO AT VADODARA.

DRAWING TITLE:  
AC PIPING LAYOUT

DEALT BY: DIVYA  
CHK. BY:  
DATE: 08/11/24  
SCALE: N.T.S.  
ALT.NO:  
NORTH:  
FILE:

**Wistaar**  
ARCHITECTS & INTERIOR DESIGNERS  
A/702, NAR NARAYAN  
NR.NAVRANGPURA P.O.,  
SWASTIK CROSS ROADS,  
AHMEDABAD - 380 009,  
TEL: 079 - 2644 8361.4006 1526  
M: 073830 97334  
E-Mail : wistaar.arch@gmail.com