


Electrical layout

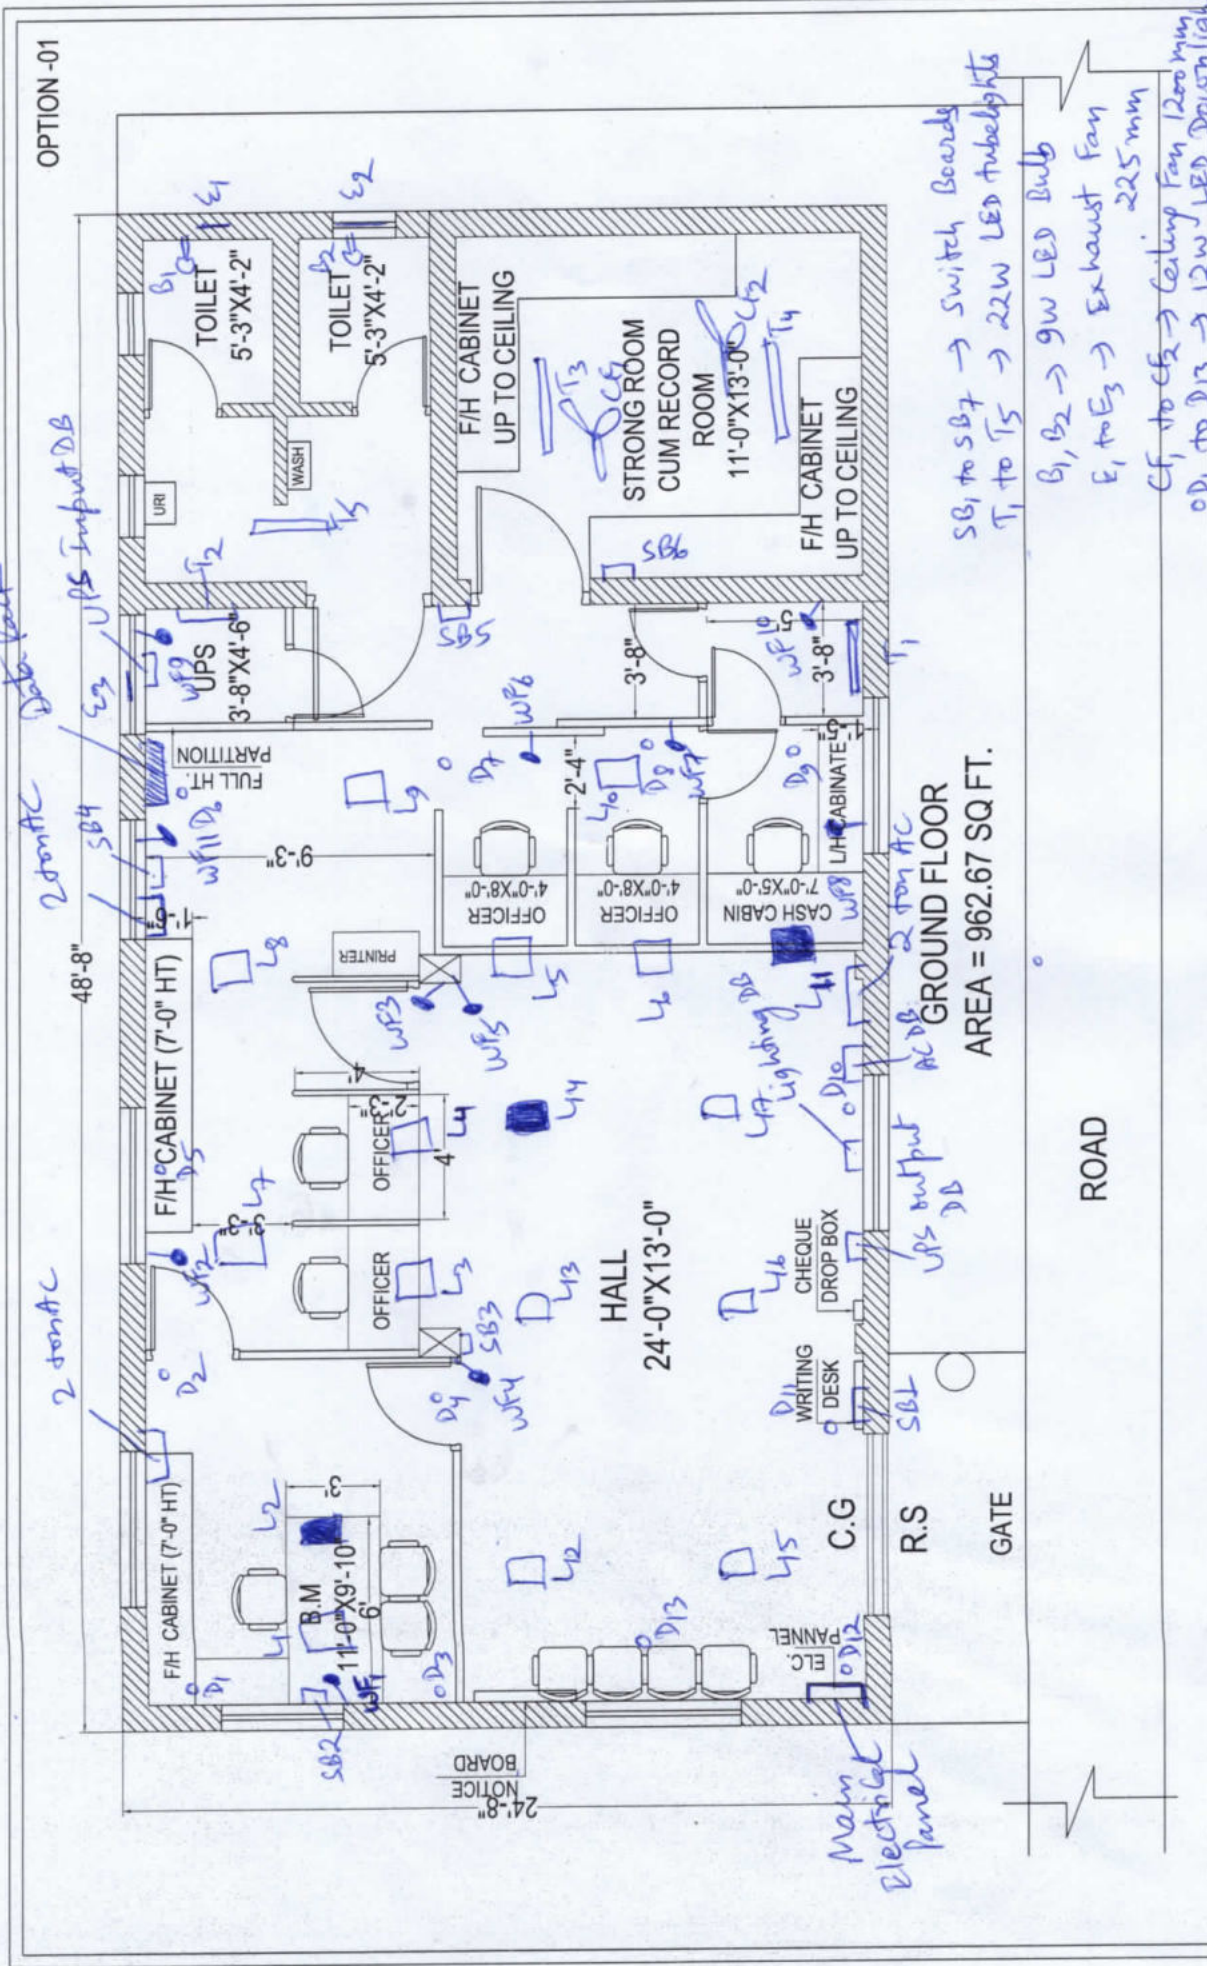

SB₁ to SB₇ → Switch Boards
 T₁ to T₅ → 22W LED tubelights
 B₁, B₂ → 9W LED Bulb
 E₁ to E₃ → Exhaust Fan 225 mm
 CF₁ to CF₂ → Ceiling Fan 200 mm
 OD₁ to OD₃ → 12W LED Downlighter

GROUND FLOOR
 AREA = 962.67 SQ. FT.

Design Oriented Techniques
 Thapar Road, Ranchi-834001
 Email: doct@doct.com
 Web: www.doct.com
 Tel: 09304114276, 9471500077
 WWW.Architects.in



SHEET NO - ARC/01
 DATE - 2025.01.07

EXISTING INTERIOR LAYOUT FOR CANARA BANK AT
 MARWARI COLLEGE, RANCHI.

D₄ to L₇ → 36W LED 2x2 Light
 → lights connected with ULS power
 → 300mm wall mounted Fan