


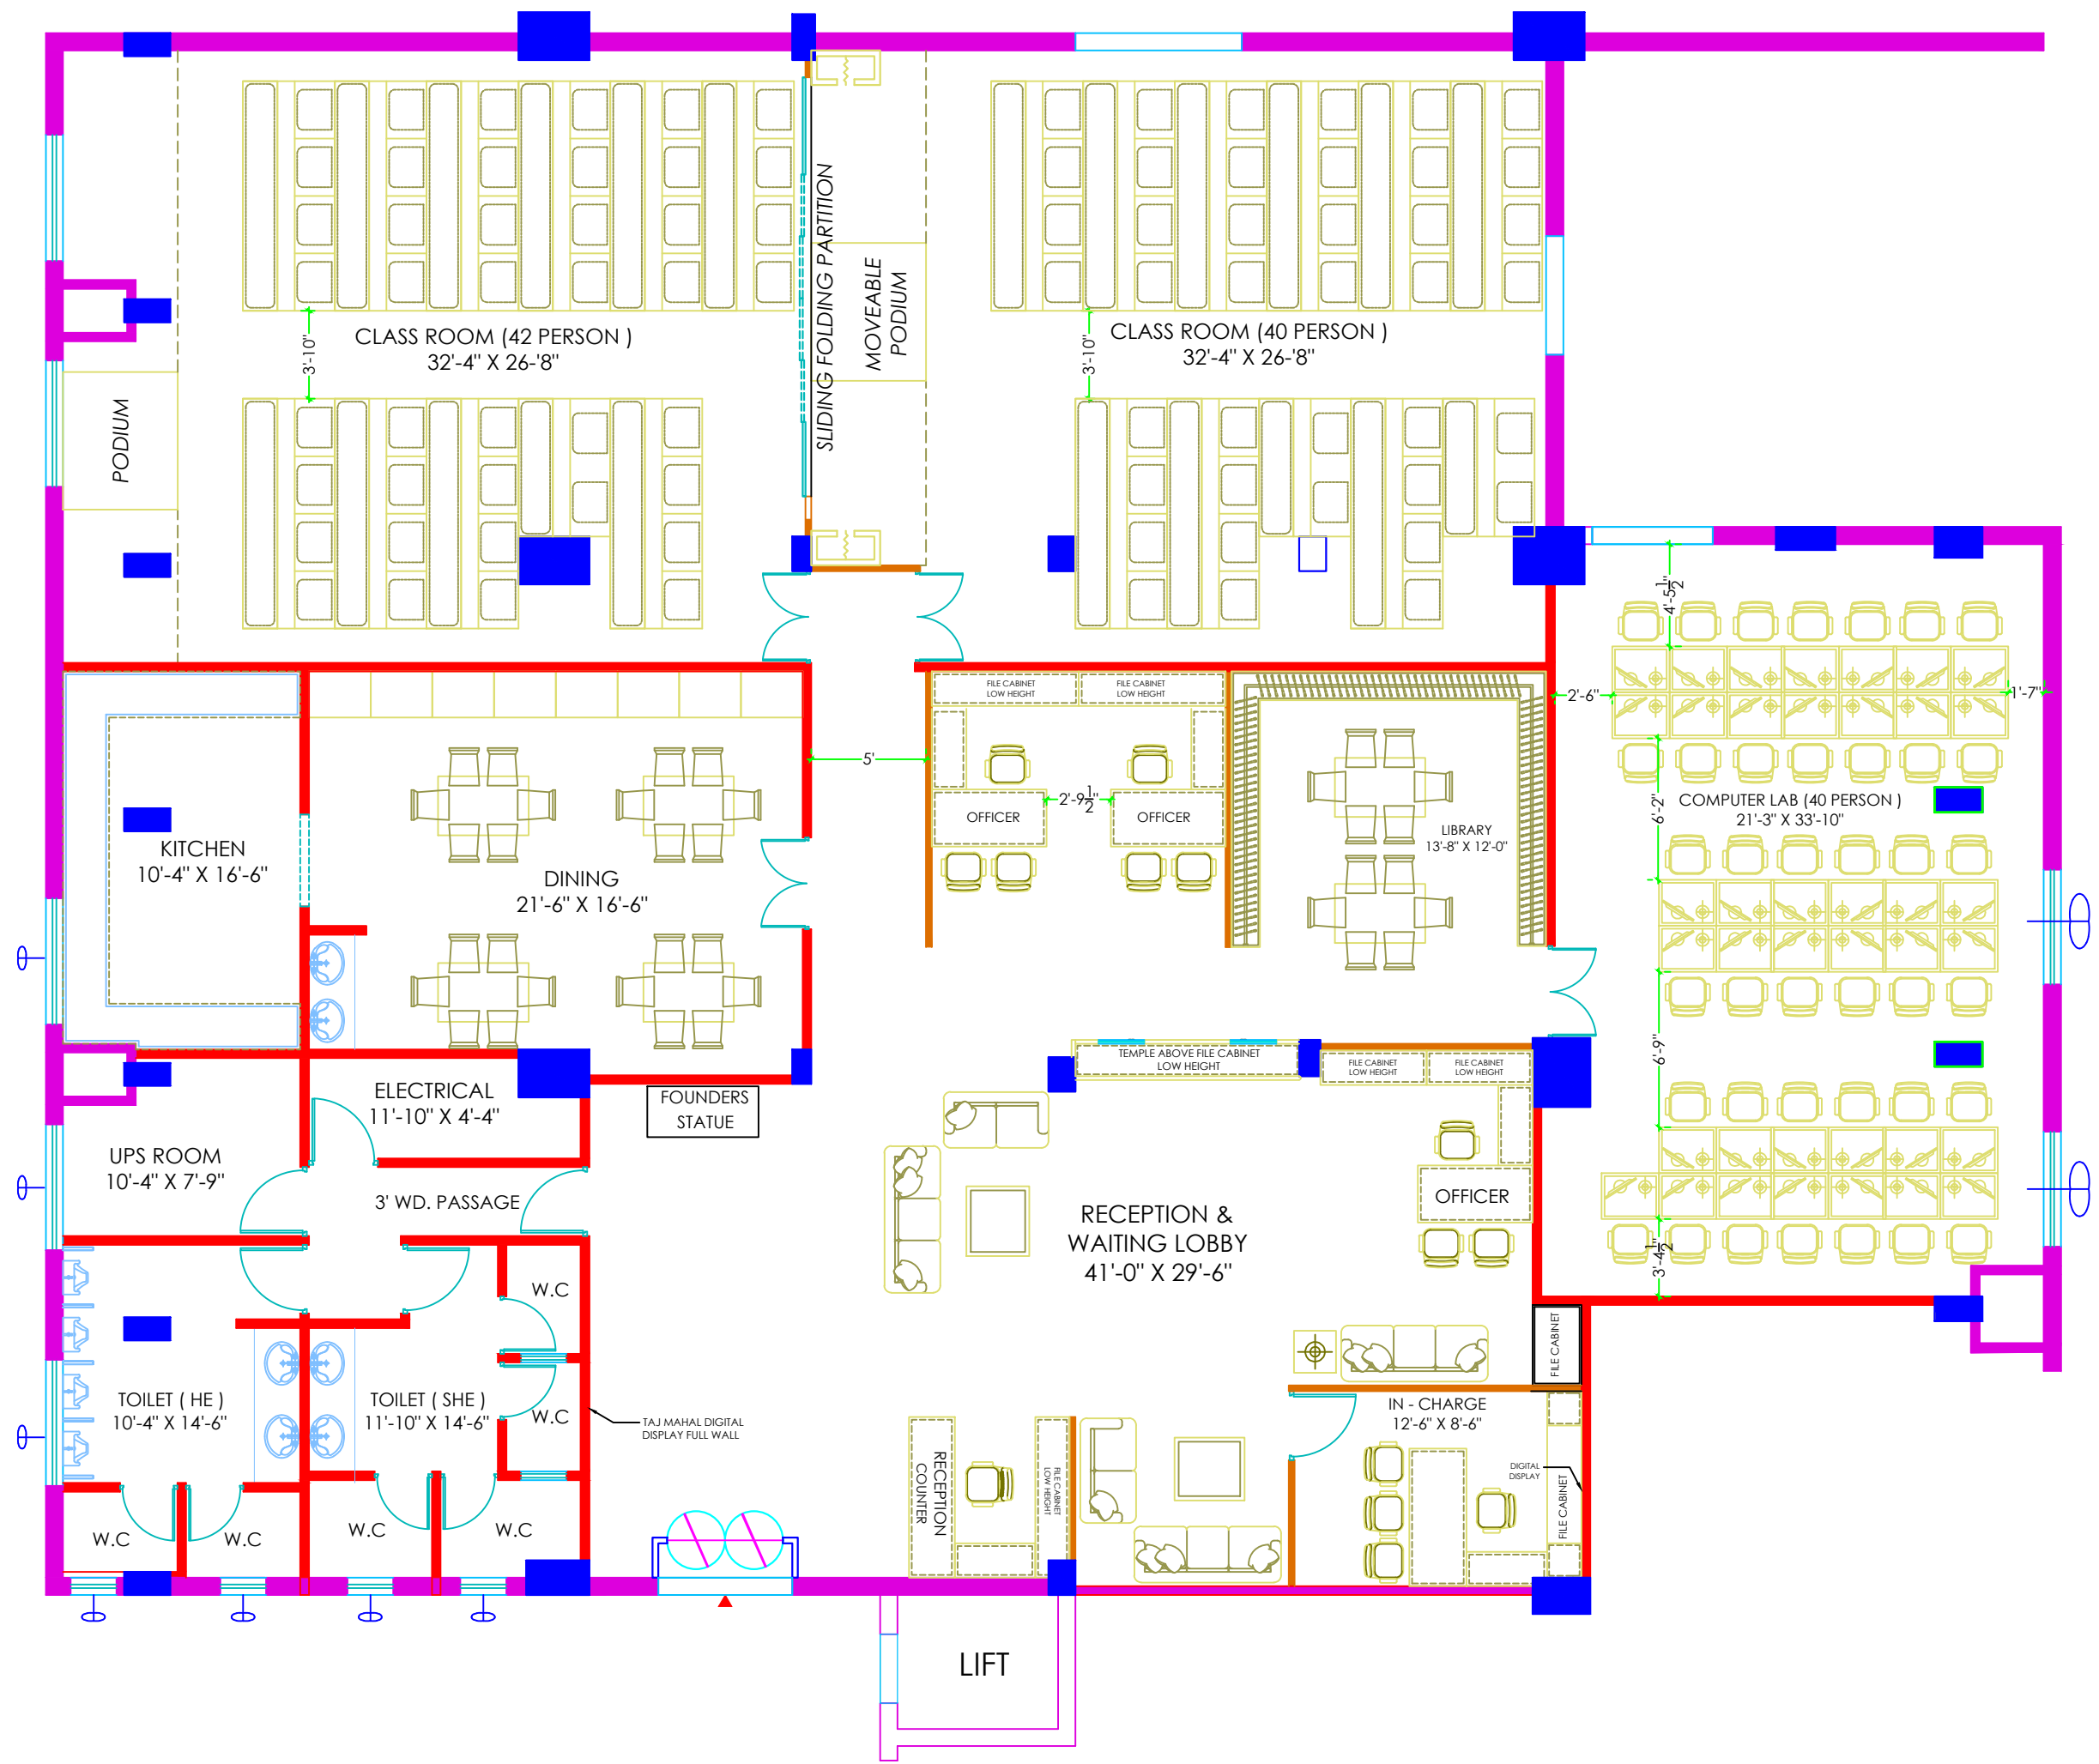

JOB TITLE ;

PROPOSED INTERIOR
LAYOUT PLAN FOR
CANARA BANK, LDC,
AT CIRCLE OFFICE
AGRA

SHEET TITLE ;

PROPOSED
FURNITURE PLAN

- EXTERNAL BRICK WALL
- PROPOSED WOOD WORK
- PROPOSED BRICK WORK

OWNER;-

Chkd By. Mrs.ARCHANA

DRG NO: AR/001

Date

NORTH



Ar.ARCHANA YADAV
ARCHITECT,ENGINEER&INTERIOR DESIGNER

VISHWAKARMA PLAZA,G -17,SECTOR-16-B,
AWAS VIKAS COLONY,SIKANDRA, AGRA.
PH. NO:9319102421
e-mail:-ar_archana_yadav@yahoo.co.in

JOB TITLE ;

PROPOSED INTERIOR
LAYOUT PLAN FOR
CANARA BANK, RSTC,
AT CIRCLE OFFICE
AGRA

SHEET TITLE ;

PROPOSED
CEILING PLAN

- EXTERNAL BRICK WALL
- PROPOSED WOOD WORK
- PROPOSED BRICK WORK

OWNER;-

Chkd By. Mrs.ARCHANA

DRG NO: AR/001


Date 08-JAN-2025

NORTH



Ar.ARCHANA YADAV
ARCHITECT,ENGINEER&INTERIOR DESIGNER

VISHWAKARMA PLAZA,G -17,SECTOR-16-B,
AWAS VIKAS COLONY,SIKANDRA, AGRA.
PH. NO:9319102421
e-mail:-ar_archana_yadav@yahoo.co.in

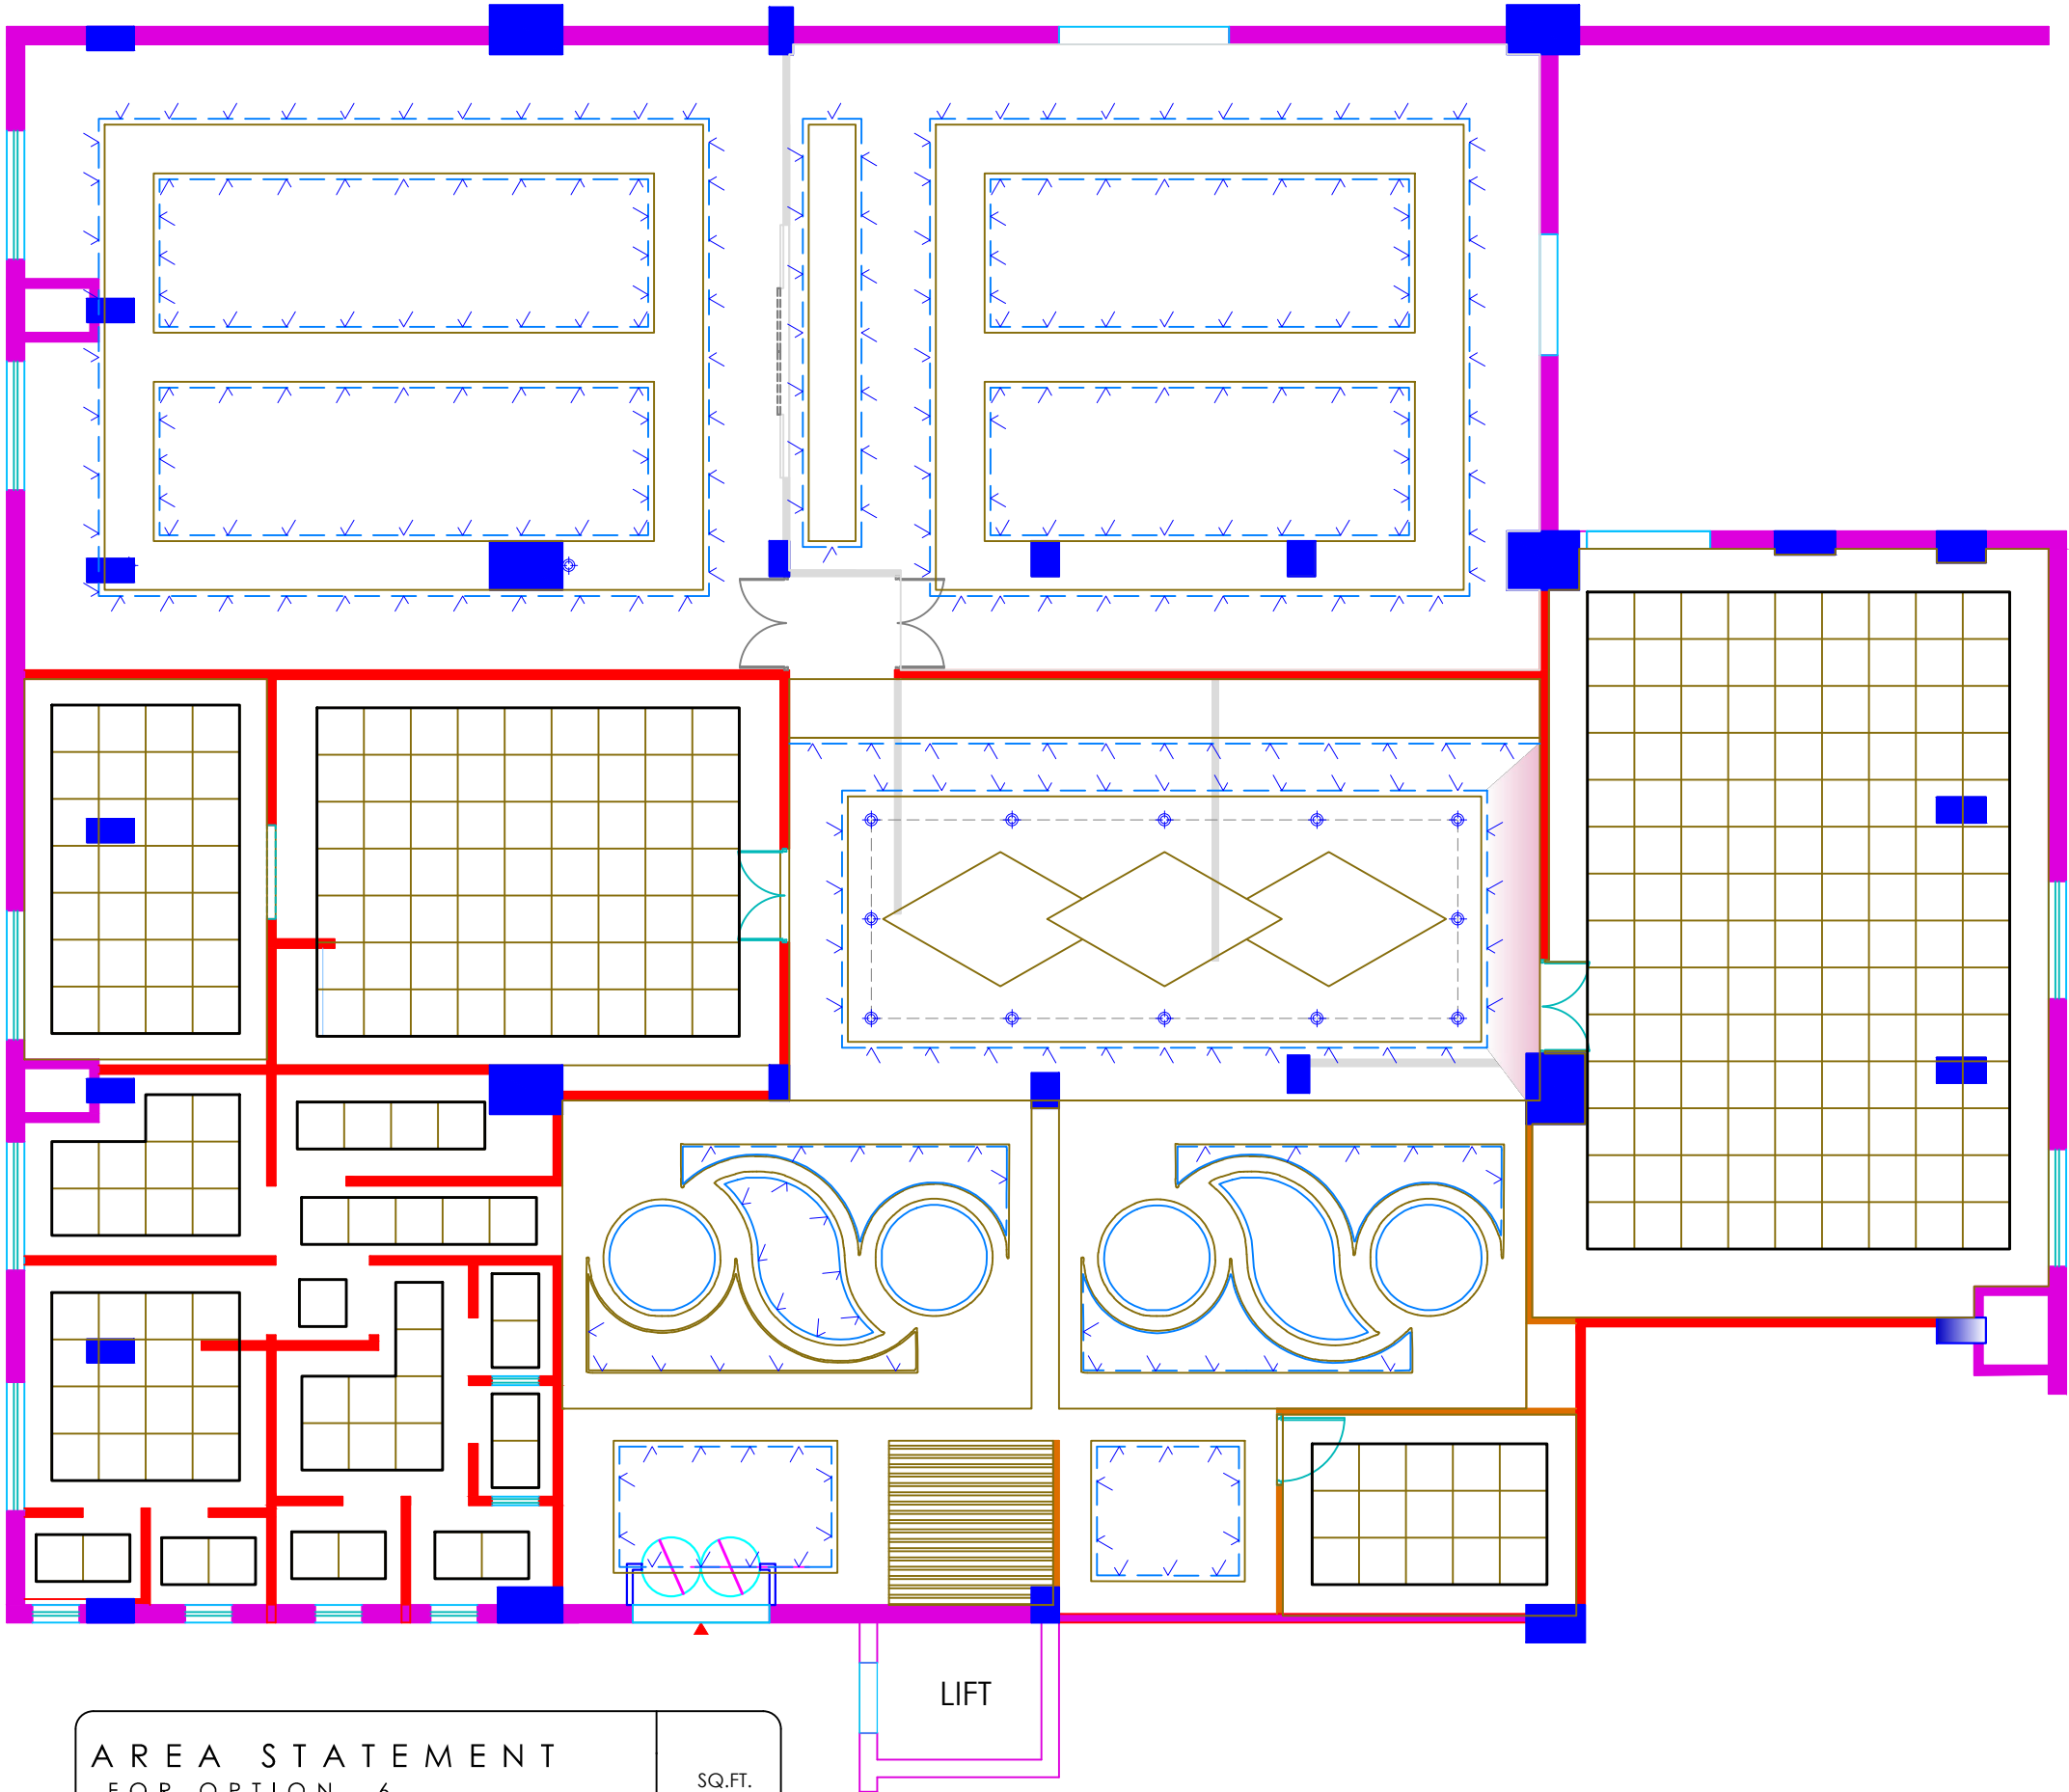

AREA STATEMENT
FOR OPTION - 6

		SQ.FT.
1.	TOTAL COVERED AREA	5046.26
2.	DEDUCTION COLUMN & WALL AREA	125.24
3.	DEDUCTION TOILET AREA	340.88
4.	NET AREA	4580.14

OPTION -9

PROPOSED INTERIOR
LAYOUT PLAN FOR
CANARA BANK, RSTC,
AT CIRCLE OFFICE
AGRA

PROPOSED ELECTRICAL PLAN

OWNER;-

Chkd By. Mrs.ARCHANA

DRG NO:	AR/001
---------	--------


Date	08-JAN-2025
------	-------------

NORTH



Ar.ARCHANA YADAV
ARCHITECT,ENGINEER&INTERIOR DESIGNER

VISHWAKARMA PLAZA,G -17,SECTOR-16-B.
AWAS VIKAS COLONY,SIKANDRA, AGRA.
PH. NO:9319102421
e-mail:-ar archana yadav@yahoo.co.in

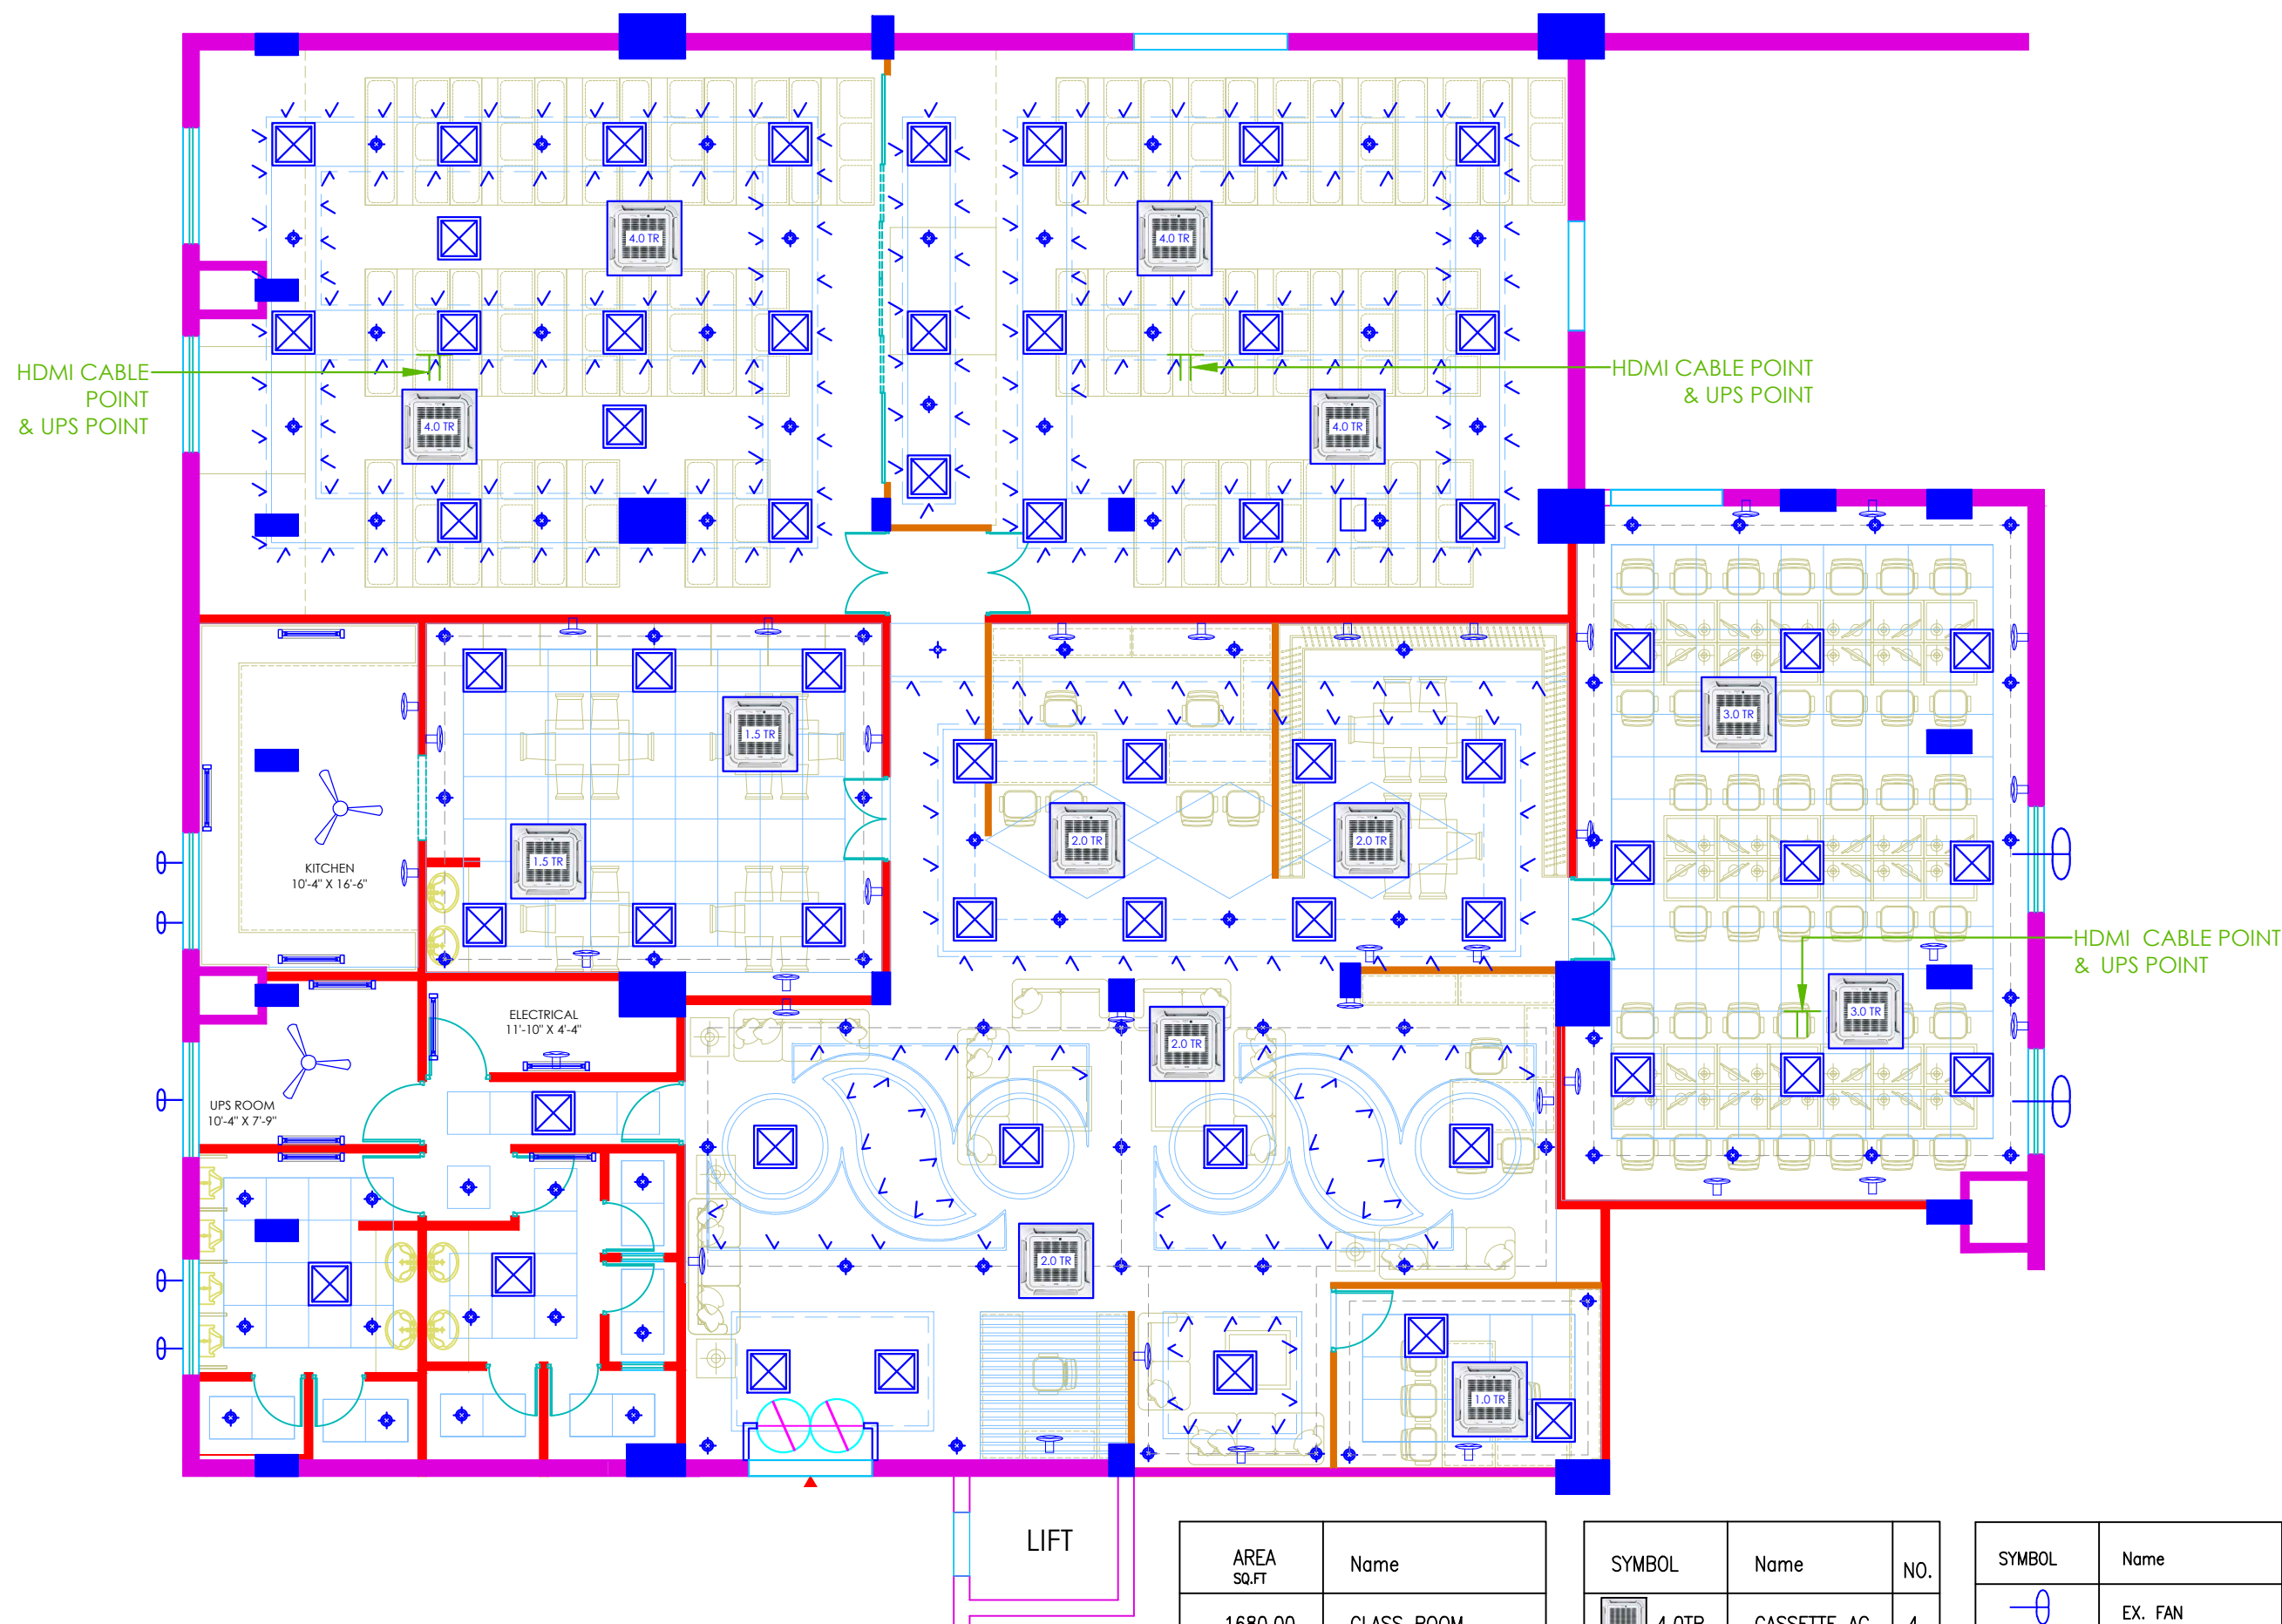

OPTION -10

AREA SQ.FT	Name
1680.00	CLASS ROOM
363.00	DINING ROOM
1382.00	RECEPTION & LOBBY
688.00	COMPUTER LAB
105.45	IN CHARGE OFFICE

SYMBOL	Name	NO
 4.0TR	CASSETTE AC	4
 3.0TR	CASSETTE AC	2
 2.0TR	CASSETTE AC	4
 1.5TR	CASSETTE AC	2
 1.0TR	CASSETTE AC	1

SYMBOL	Name
	EX. FAN
	AC
	LIGHT 2'X2'
	HDMI & UPS PORT
	TUBE LIGHT
	WALL FAN

JOB TITLE ;

PROPOSED INTERIOR
LAYOUT PLAN FOR
CANARA BANK, RSTC,
AT CIRCLE OFFICE
AGRA

SHEET TITLE ;

PROPOSED
ELECTRICAL PLAN

- EXTERNAL BRICK WALL
- PROPOSED WOOD WORK
- PROPOSED BRICK WORK

OWNER;-

Chkd By. Mrs.ARCHANA

DRG NO: AR/001


Date 08-JAN-2025

NORTH



Ar.ARCHANA YADAV
ARCHITECT,ENGINEER&INTERIOR DESIGNER

VISHWAKARMA PLAZA,G -17,SECTOR-16-B,
AWAS VIKAS COLONY,SIKANDRA, AGRA.
PH. NO:9319102421
e-mail:-ar_archana_yadav@yahoo.co.in

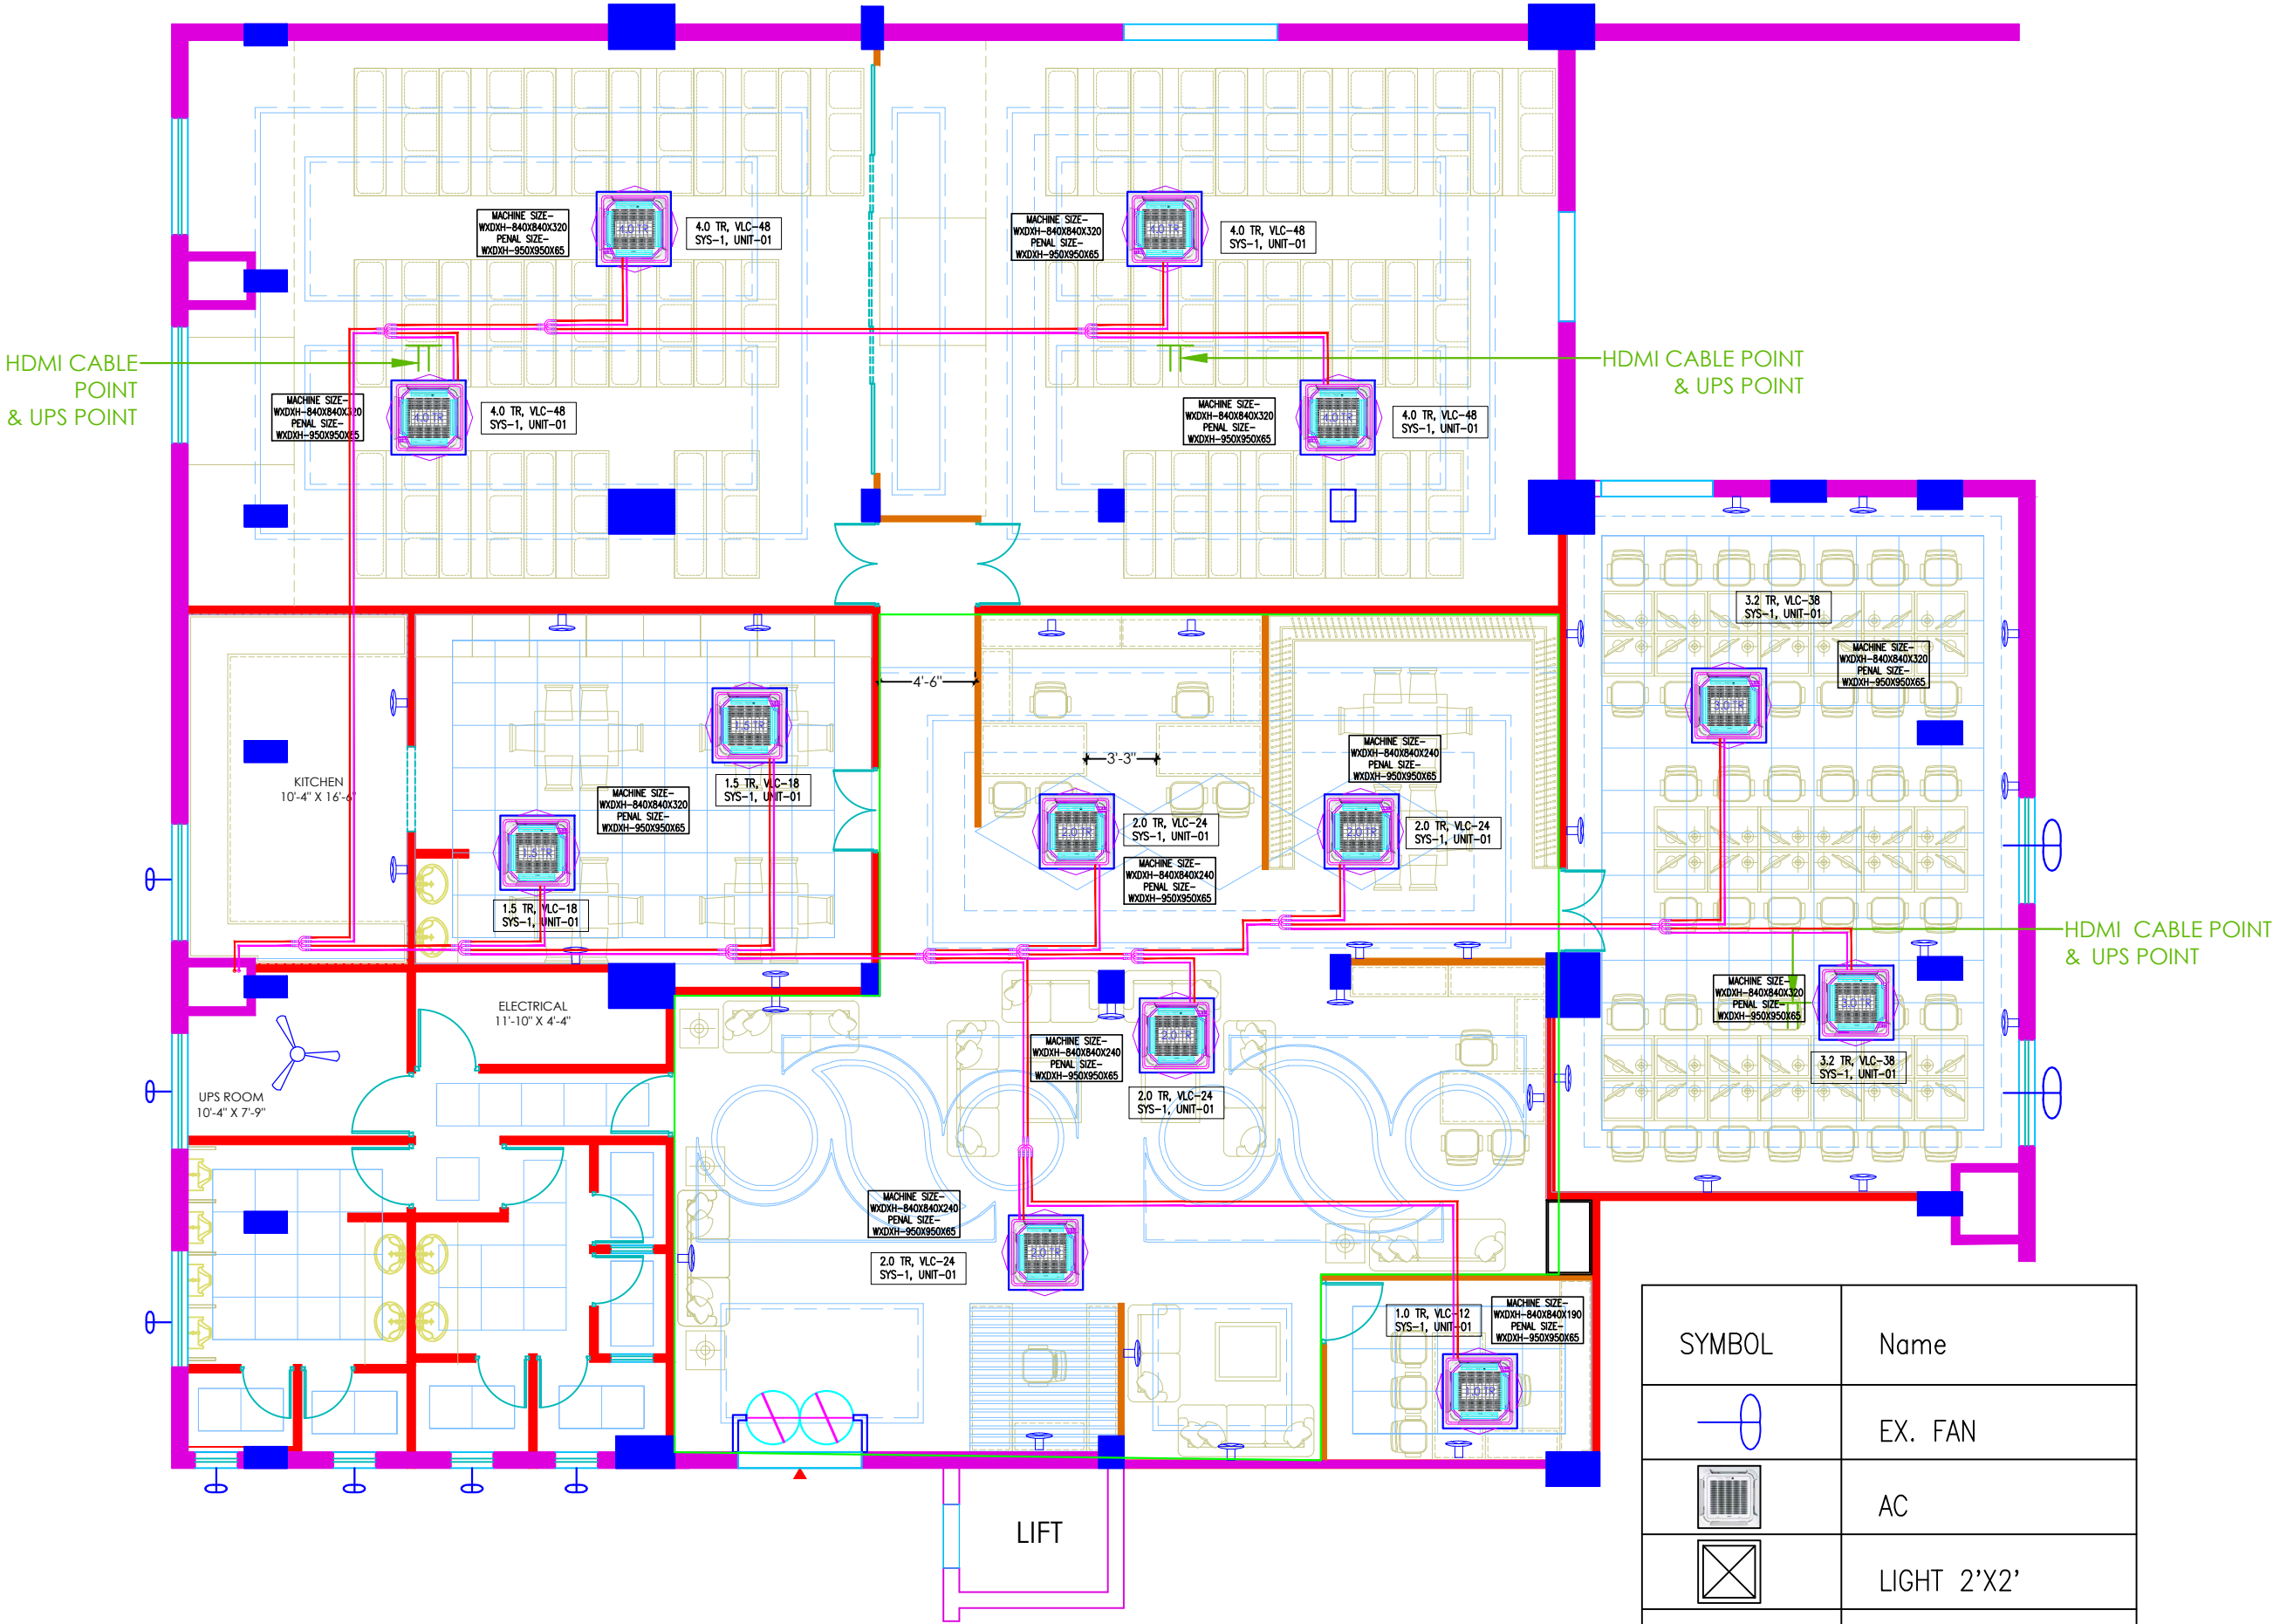

OPTION -10