

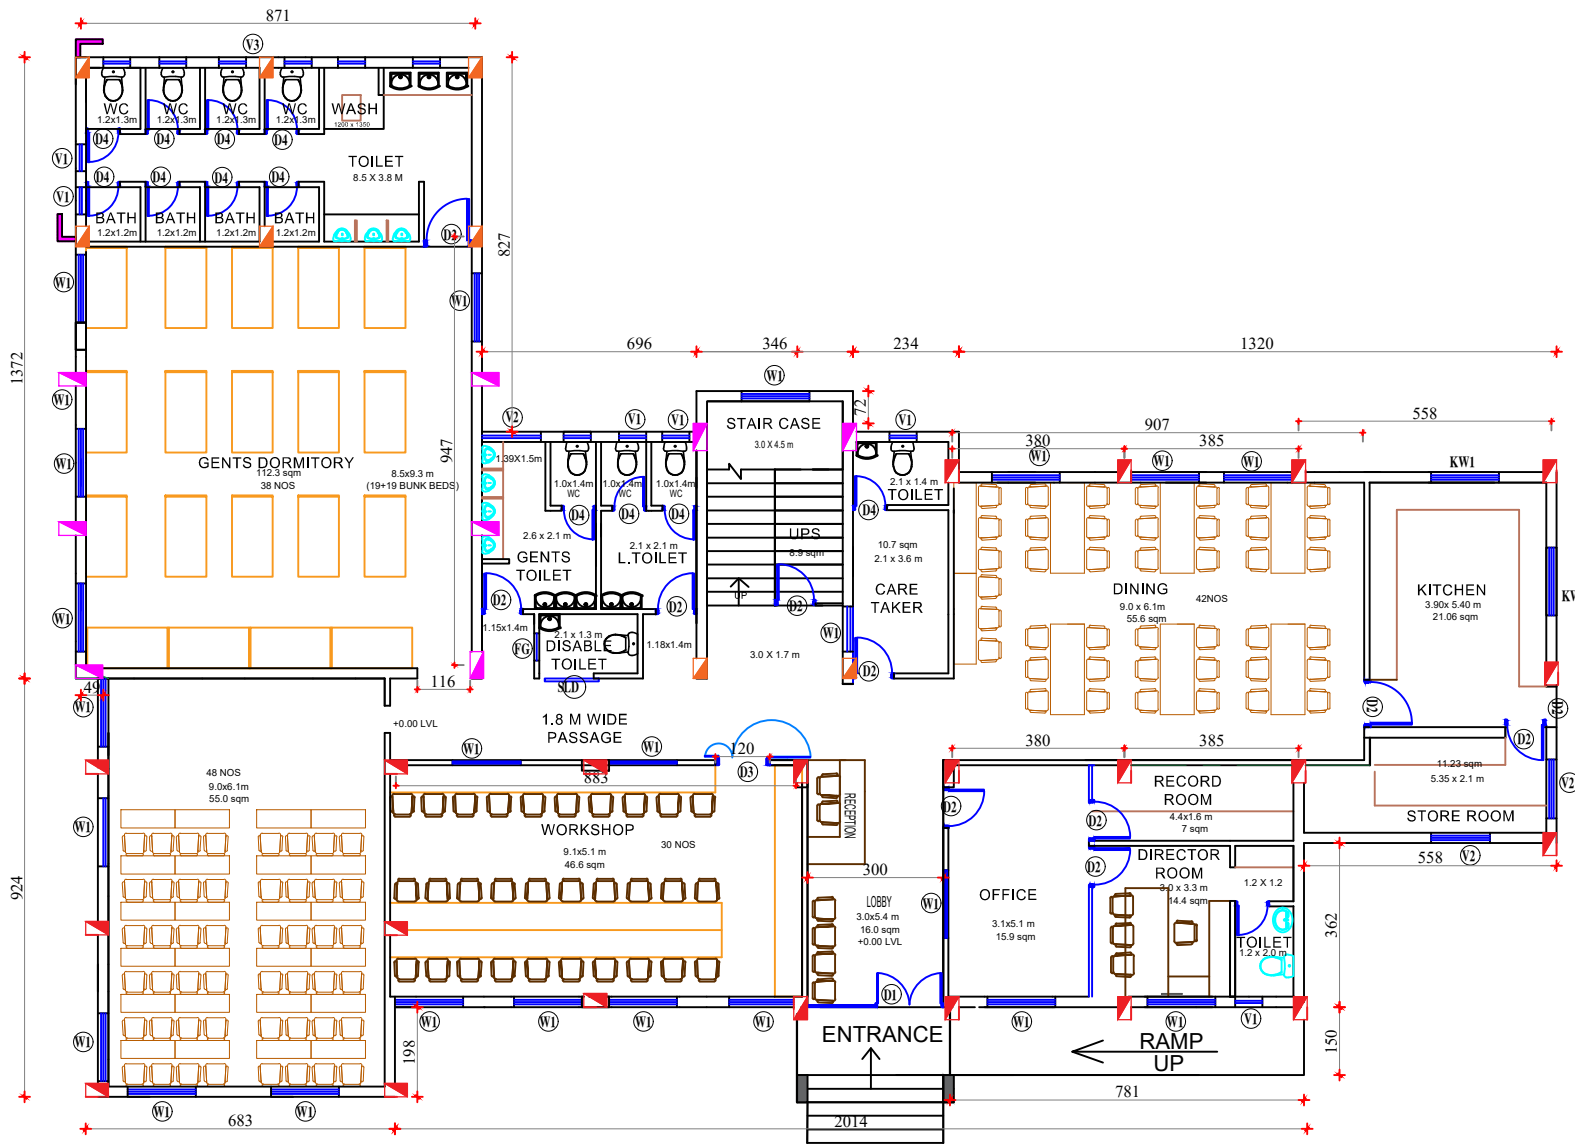


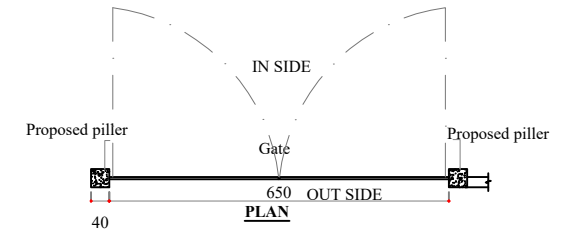

GROUND FLOOR PLAN
Area:-470.29Sq.m(5060.32 Sft)

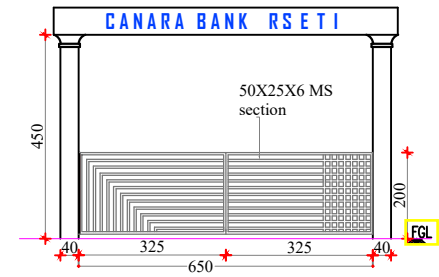

Revisions

S.No	Rev: Date	Remarks	Sign	Check
	07-12-020			
	11-12-020			

Scale :	NTS	Date :	21-06-2022
DC :		Dealt :	
Checked :		Drawn By :	Aji
Drawing No :	001a	Job no :	

ALL DIEMENSIONS ARE IN CENTIMETERS

Title: **FINAL GF PLAN**

Name of work:

CB RSETI @ KOTTIYAM

Clients Signature:-


Client : CANARA BANK,
RD Section,FI Wing,
HO Annexe,Gandhinagar,
Bangalore-560009

Architects Signature & seal:-

Architect

Prima Arch

Joseph George
Architect, CA-84/ 8733,REG Valuer-F-3047)
359 - E, 1st Floor
Convent Road, Cherthala - 688 524
PH - 0478 - 2820159
E-mail primaarch@gmail.com

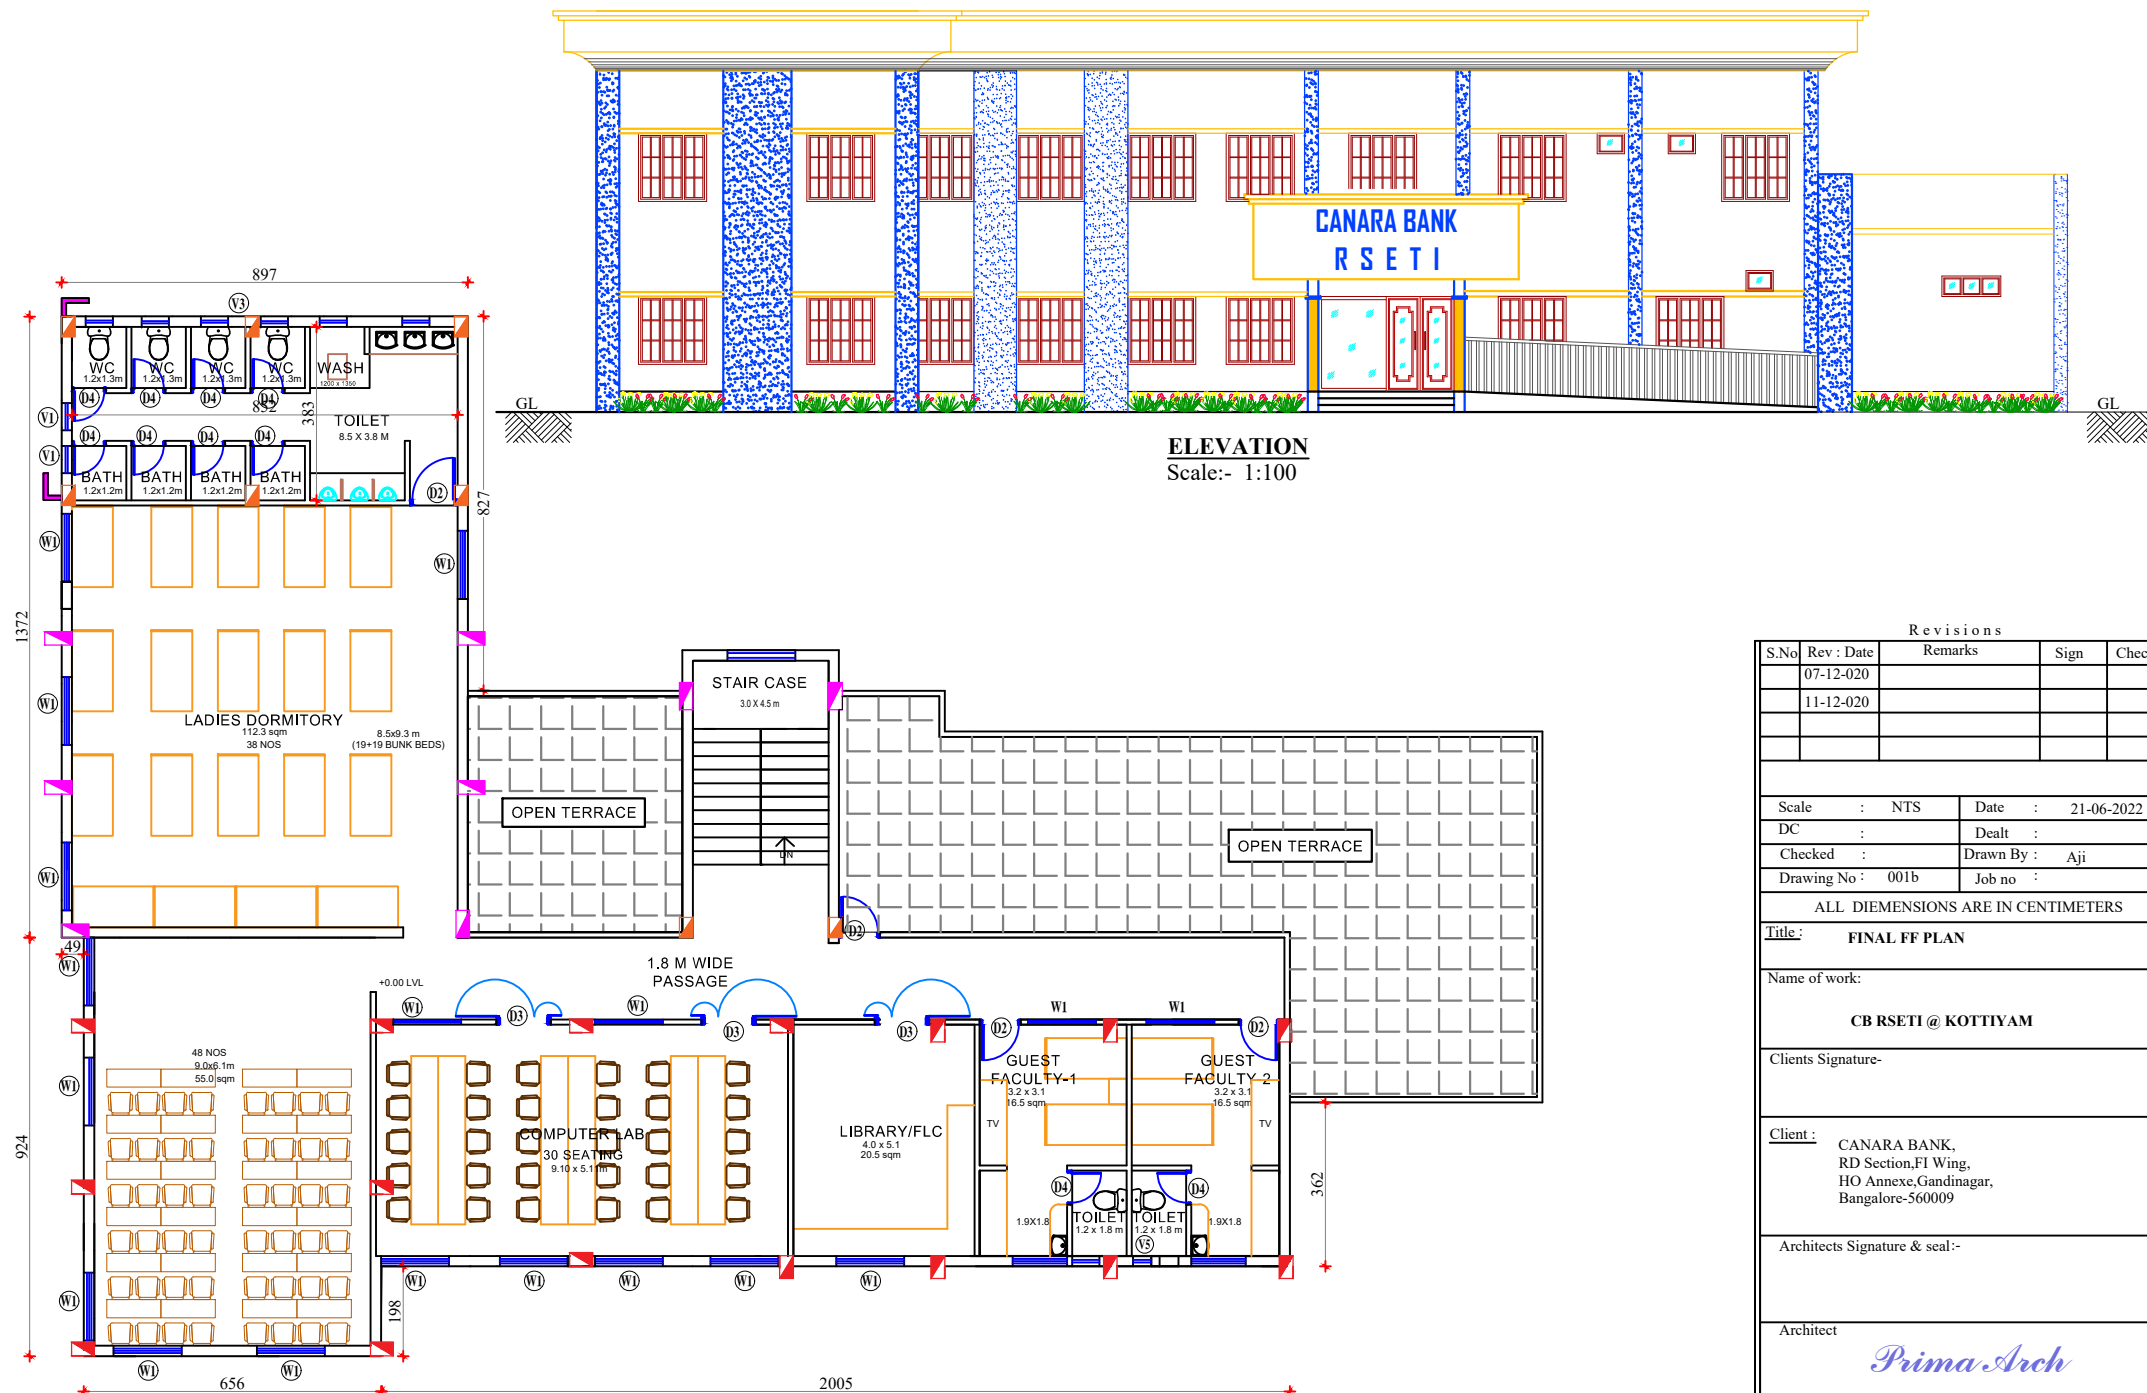

Revisions

S.No	Rev : Date	Remarks	Sign	Check
	07-12-020			
	11-12-020			

Scale	: NTS	Date	: 21-06-2022
DC	:	Dealt	:
Checked	:	Drawn By	: Aji
Drawing No	: 001b	Job no	:

ALL DIEMENSIONS ARE IN CENTIMETERS

Title : **FINAL FF PLAN**

Name of work:

CB RSETI @ KOTTIVAM

Clients Signature-

 

Client : CANARA BANK,
 RD Section,FI Wing,
 HO Annexe,Gandinagar,
 Bangalore-560009

Architects Signature & seal:-

Architect

Prima Arch

Joseph George
 Architect, CA-84/ 8733,REG Valuer-F-3047)
 359 - E, 1st Floor
 Convent Road, Cherthala - 688 524
 PH - 0478 - 2820159
 E-mail primaarch@gmail.com

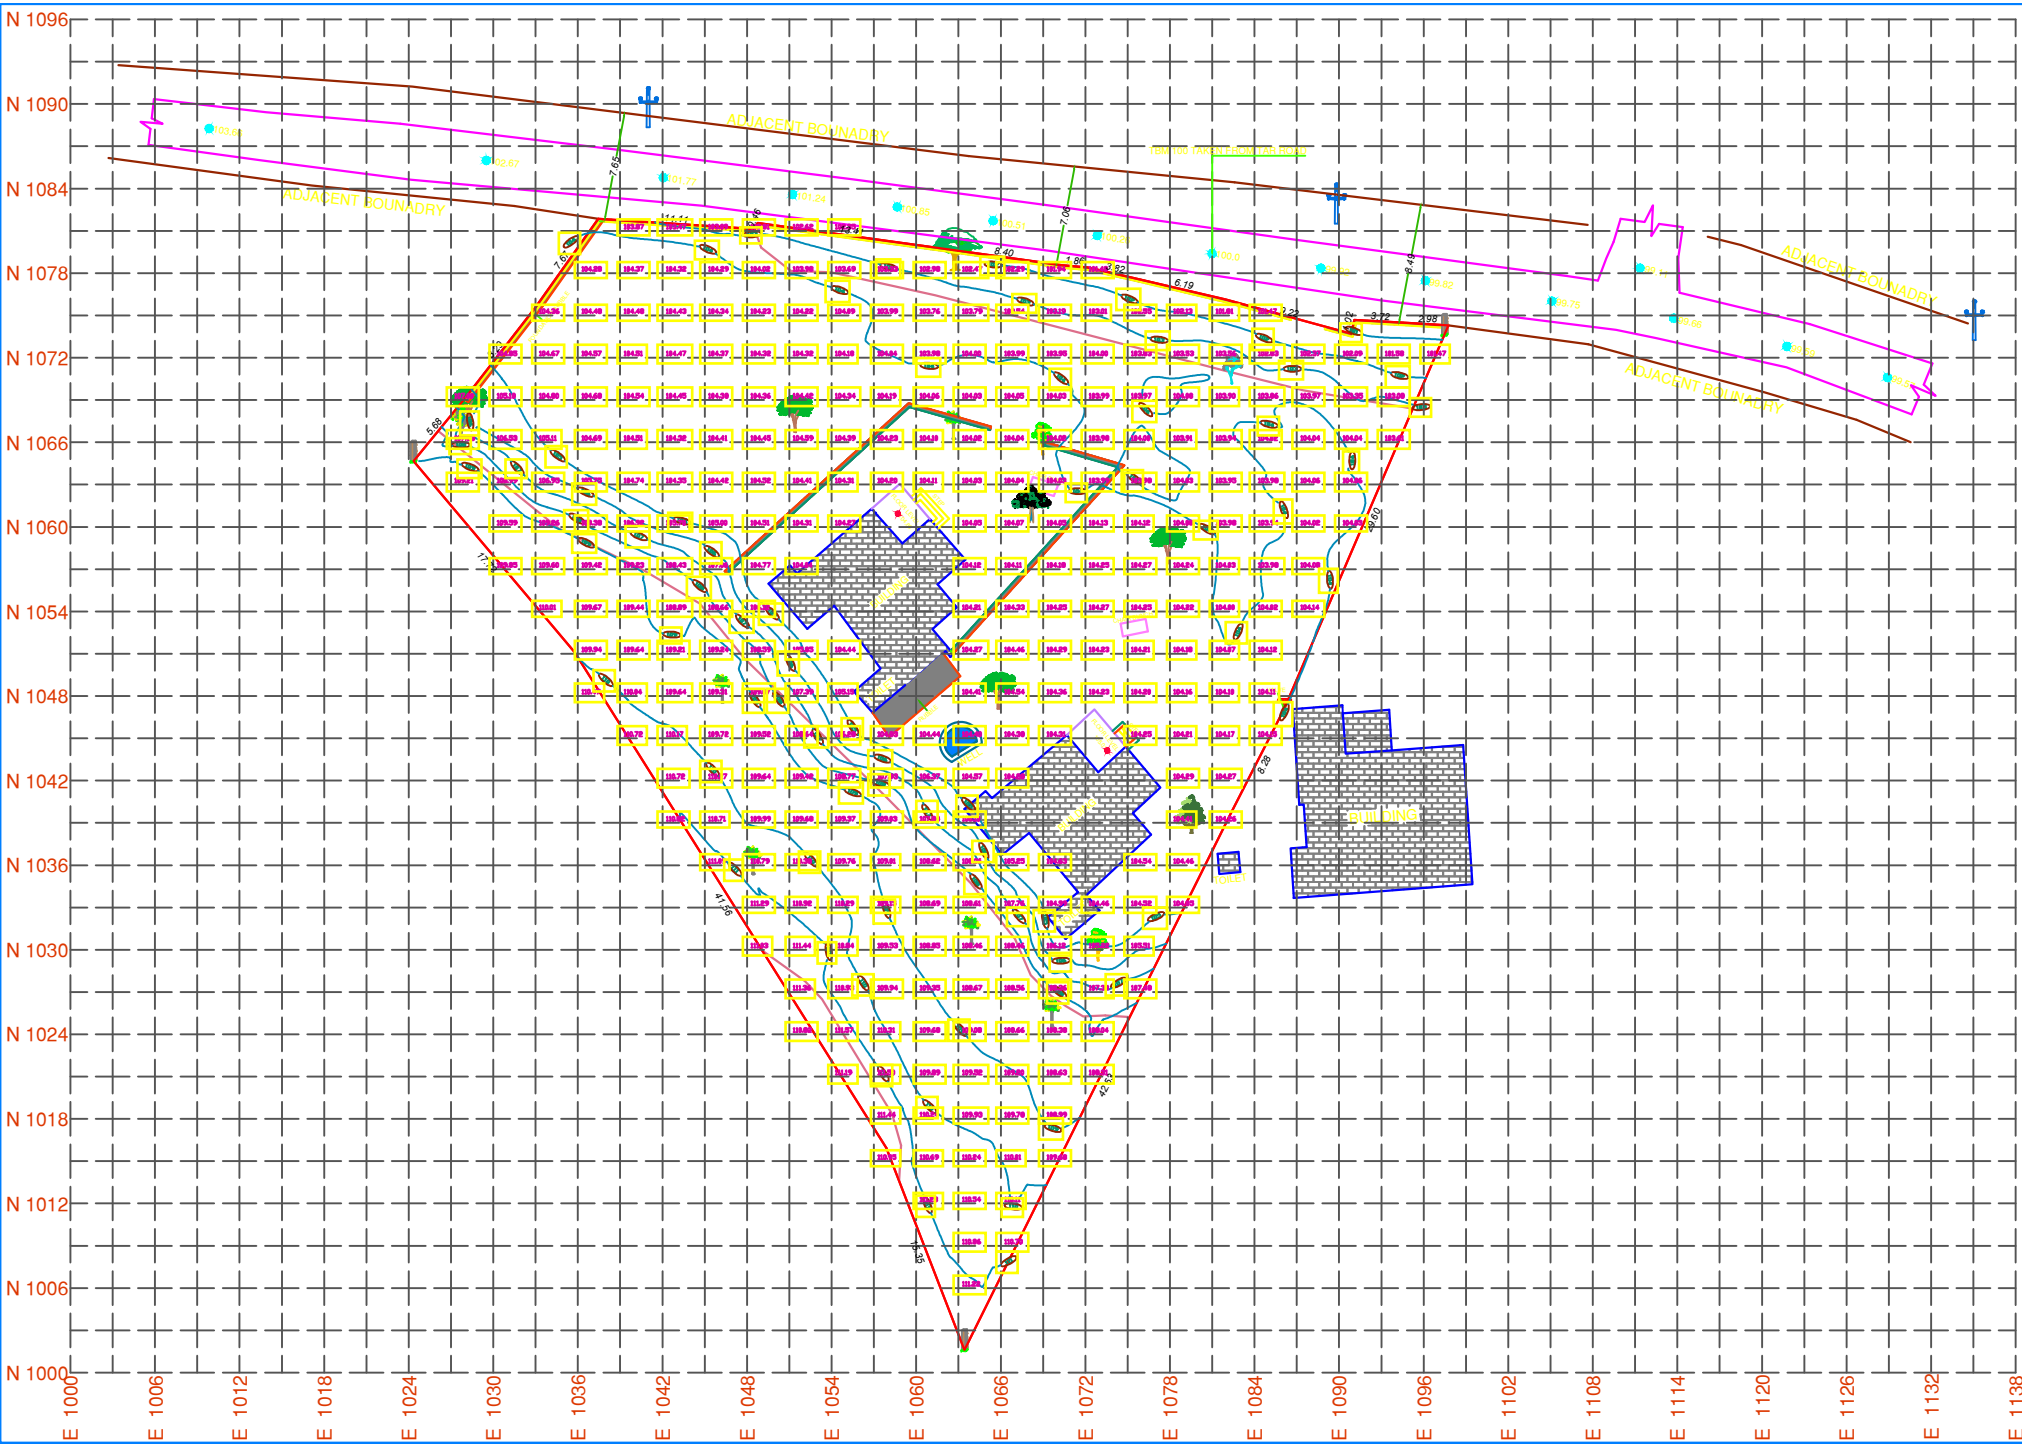

SCALE : 1:100	
DATE	02/04/2018
DRAWN	ADARSH
CHECKED	DIXON

LEGENDS	
	SPOT LEVEL
	ELECTRIC POST
	COCONUT TREE
	OTHER TREE
	ANJILI TREE
	MAHAGONY TREE
	MANGO TREE
	KANIKONNA TREE
	PAALA TREE
	OTHER TREE 2
	RUBBLE
	WALL
	CUTTING LINE
	BOUNDARY
	TAR ROAD
	AREA

AREA - 73.48 CENT

ALL DIMENSIONS ARE IN METRE

GRID INTERVAL - 3X3 M

SURVEYED BY
RAGEESH RAHUL ATHUL


TITLE
CONTOUR & TOPO SURVEY

DRAWING CODE
002a

SITE AT
KOTTARAKARA

Architect

Prima Arch
Joseph George
Architect, CA-84/ 8733REG Valuer-F-30
359 - E, 1st Floor
Convent Road, Cherthala - 688 524
PH - 0478 - 2820159
E-mail primaarch@gmail.com

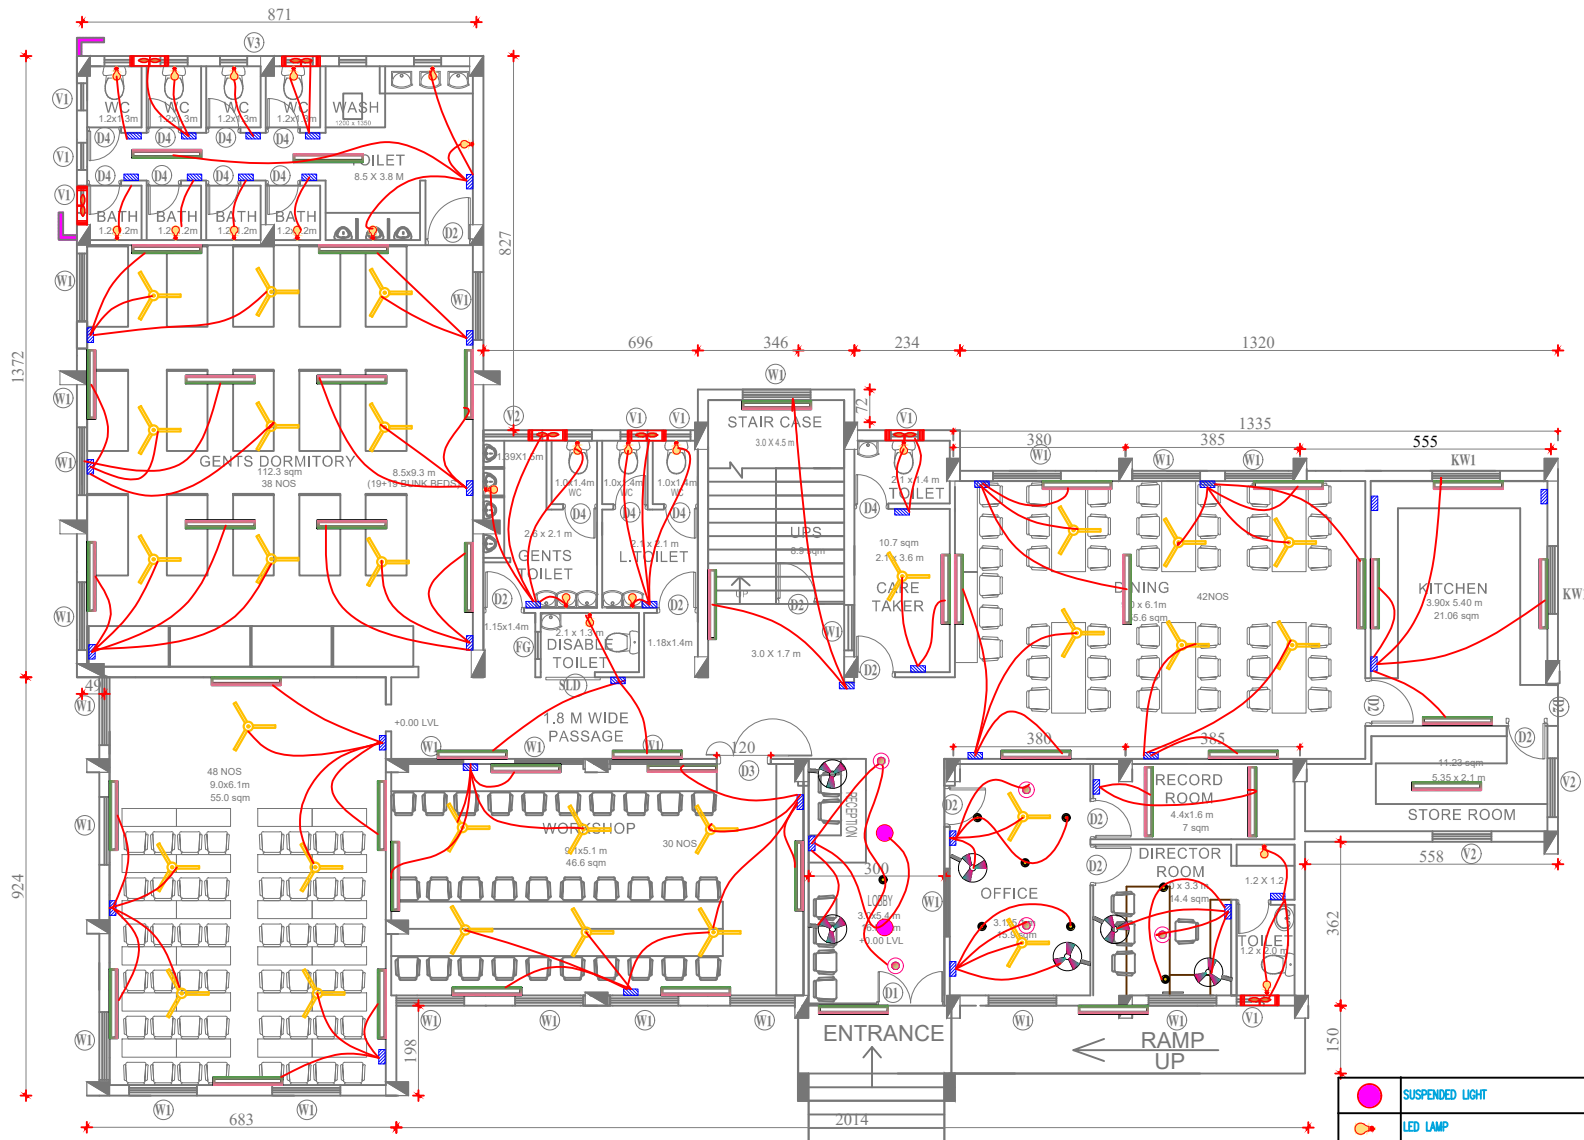

Revisions

S.No	Rev : Date	Remarks	Sign	Check
	07-12-020			
	11-12-020			

Scale :	NTS	Date :	21-08-2022
DC :		Dealt :	
Checked :		Drawn By :	Asa Sreesh
Drawing No :	003a	Job no :	

ALL DIEMENSIONS ARE IN CENTIMETERS

Title :

GROUND FLOOR ELECTRICAL LAYOUT

Name of work:

CB RSETI @ KOTTIYAM

Clients Signature-

Client :


CANARA BANK,
RD Section, FI Wing,
HO Annex, Gandinagar,
Bangalore-560009

Architects Signature & seal:-

Architect

Prima Arch

Joseph George
Architect, CA-84/ 8733, REG Valuer-F-3047/
359 - E, 1st Floor
Convent Road, Cherthala - 688 524
PH - 0478 - 2820159
E-mail primaarch@gmail.com

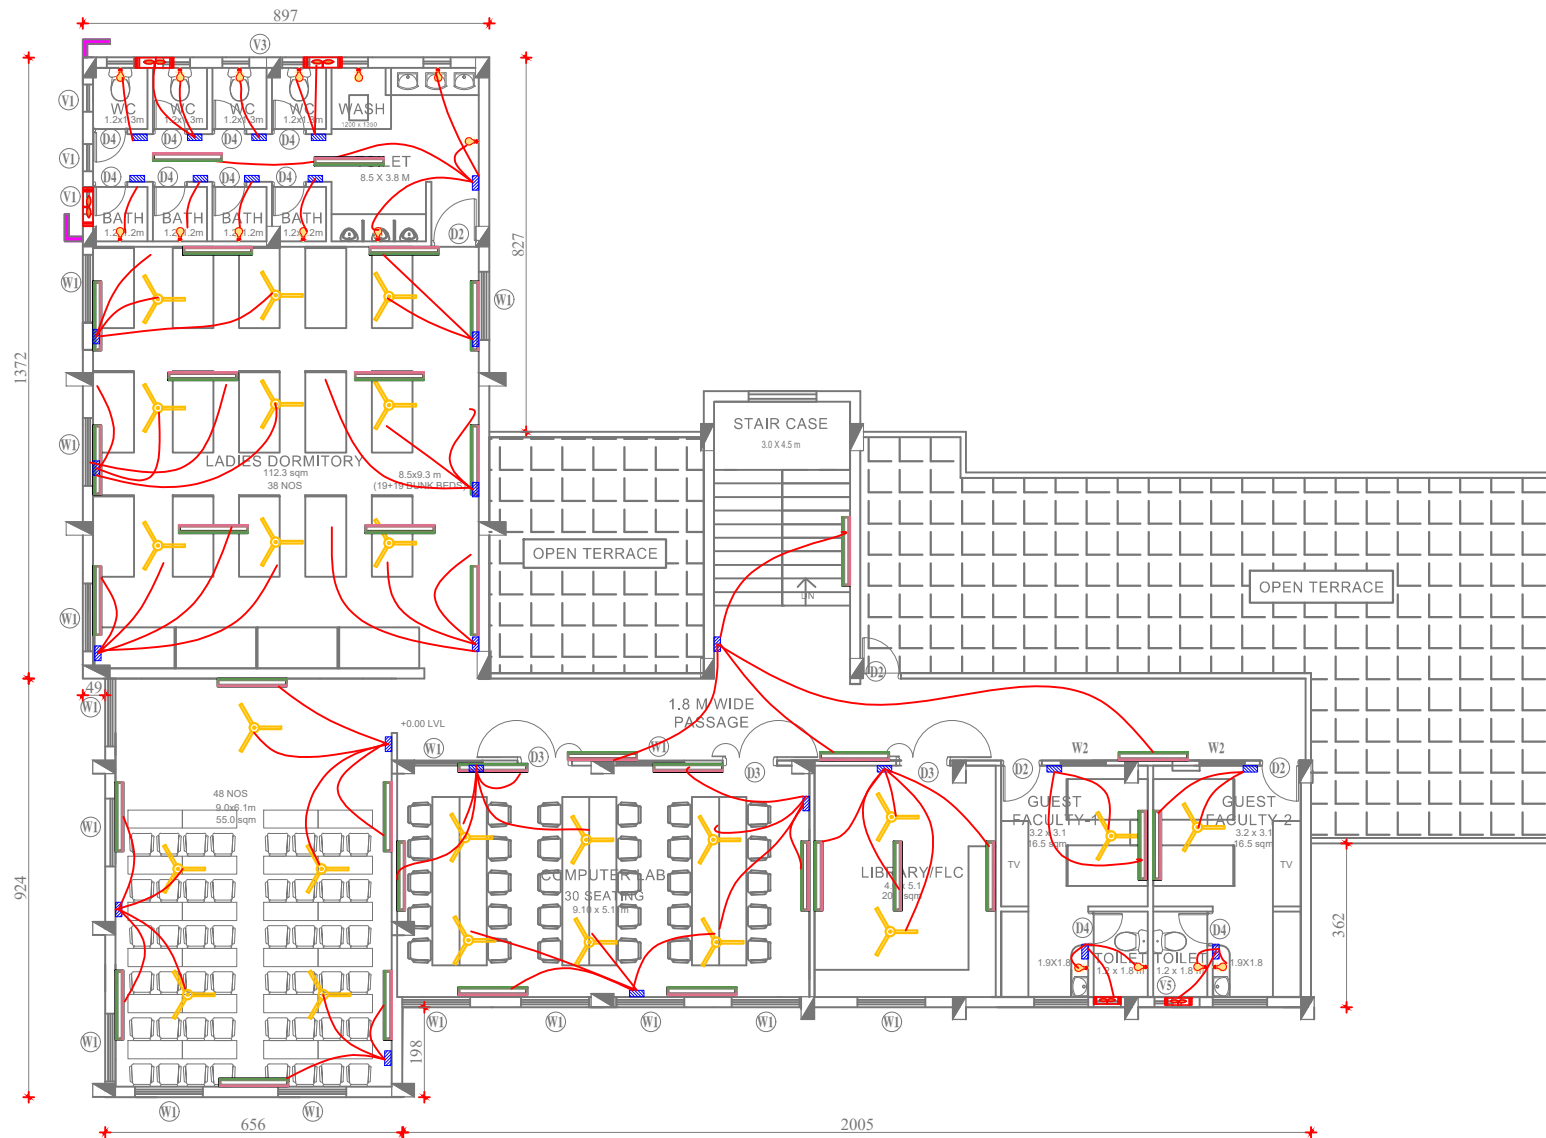

FIRST FLOOR PLAN
Area:-353.17Sq.m(3800.10Sft)

	SUSPENDED LIGHT	0
	LED LAMP	16
	1x20 LED TUBE FITTING ON WALL	35
	1200MM CEILING FAN	24
	12" EXHAUST FAN	5
	1x3W ROUND LED FITTING	0
	WALL FAN	0
	1x18 ROUND FITTING FROM INVERTER	0

Revisions

S.No	Rev : Date	Remarks	Sign	Check
	07-12-020			
	11-12-020			

Scale : NTS	Date : 21-08-2022
DC :	Dealt :
Checked :	Drawn By : Asa Sreelesh
Drawing No : 003b	Job no :

ALL DIEMENSIONS ARE IN CENTIMETERS

Title : FIRST FLOOR ELECTRICAL LAYOUT

Name of work:
CB RSETI @ KOTTIYAM



Clients Signature-

Client :
 CANARA BANK,
 RD Section, F1 Wing,
 HO Annexe, Gandinagar,
 Bangalore-560009

Architects Signature & seal:-

Architect
Prima Arch

Joseph George
 Architect, CA-84/ 8733, REG Valuer-F-3047/
 359 - E, 1st Floor
 Convent Road, Cherthala - 688 524
 PH - 0478 - 2820159
 E-mail primaarch@gmail.com

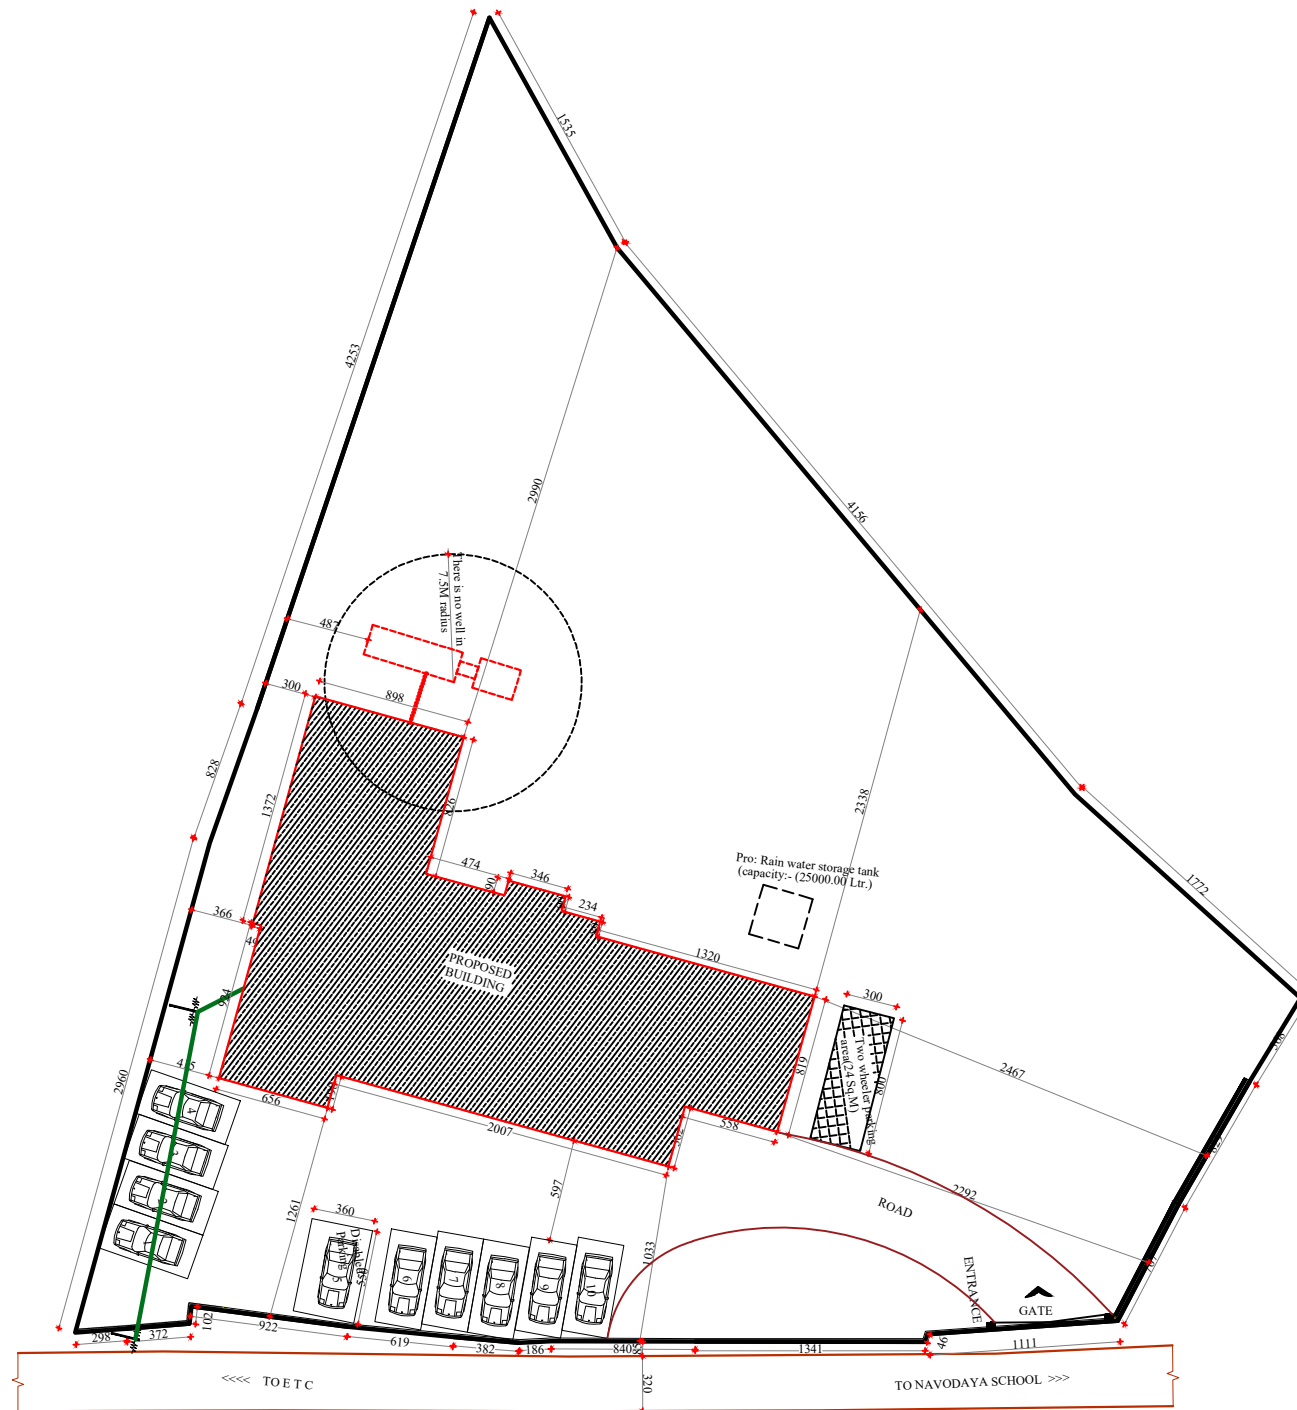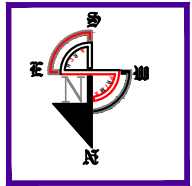

PROPOSED SITE LAYOUT

Revisions

S.No	Rev : Date	Remarks	Sign	Check
	07-12-020			
	11-12-020			

Scale :	NTS	Date :	21-06-2022
DC :		Dealt :	
Checked :		Drawn By :	Aji
Drawing No :	002b	Job no :	

ALL DIEMENSIONS ARE IN CENTIMETERS

Title : PROPOSED SITE LAYOUT

Name of work:

CB RSETI @ KOTTIVAM

Clients Signature-


Client :
CANARA BANK,
RD Section, FI Wing,
HO Annexe, Gandinagar,
Bangalore-560009

Architects Signature & seal:-


Architect

Prima Arch


Joseph George
Architect, CA-84/ 8733, REG Valuer-F-3047)
359 - E, 1st Floor
Convent Road, Cherthala - 688 524
PH - 0478 - 2820159
E-mail primaarch@gmail.com

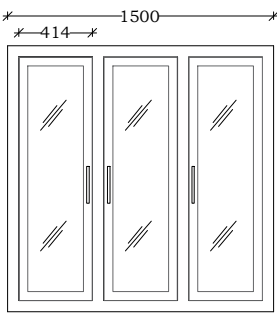


Type - UPVC WINDOWS

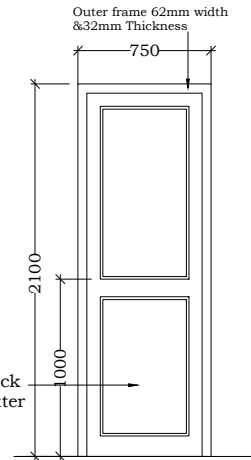


Type -PVC Door (For Toilet)

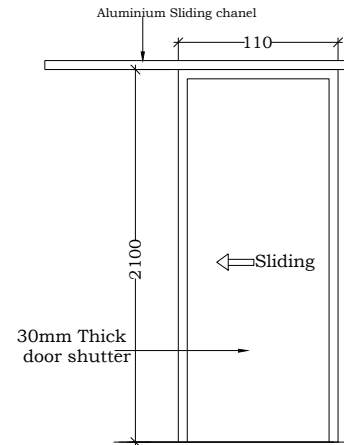

 
**Door-D1 Size 110x2100
Type -PVC Sliding Door**




Typical Ventilator Grill Detail

 


Type - UPVC VENT

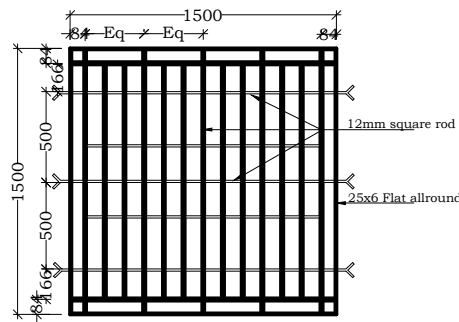

Typical Window Grill Detail

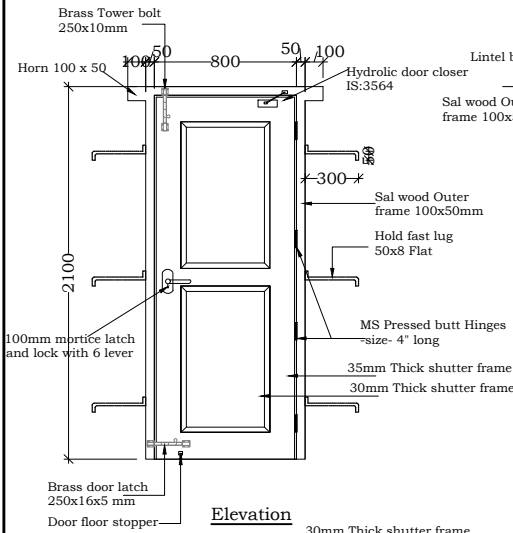


Elevation

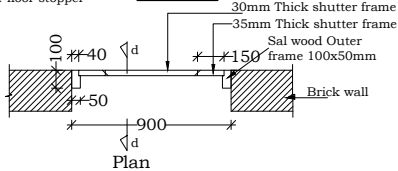


Plan


**Door-D1 Size 900x2100
[Sal wood door]**

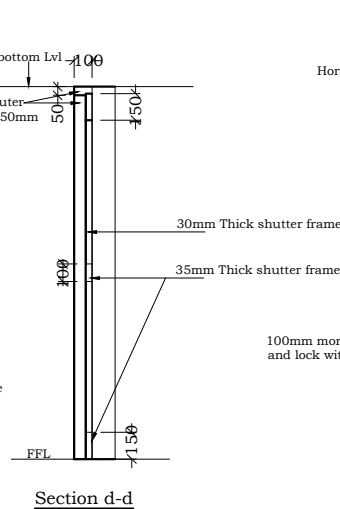

Section d-d

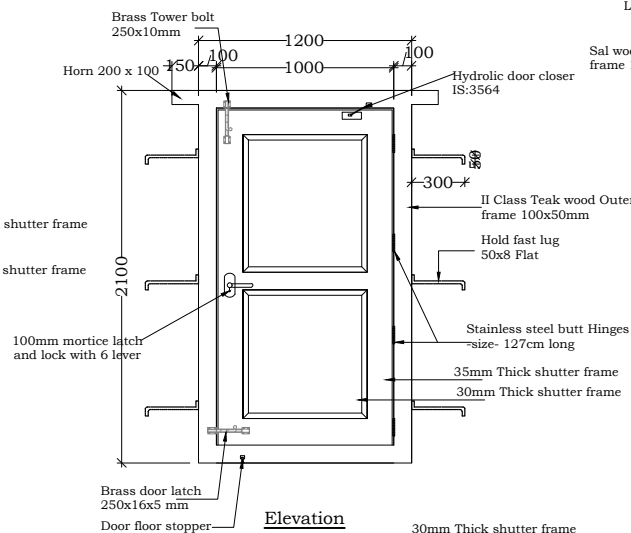


Elevation

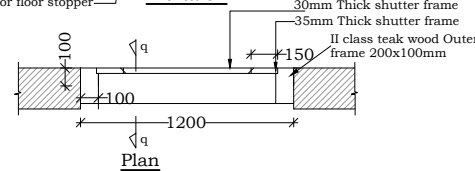

Plan

**Door-D1 Size 900x2100
[II Class Teak wood door]**

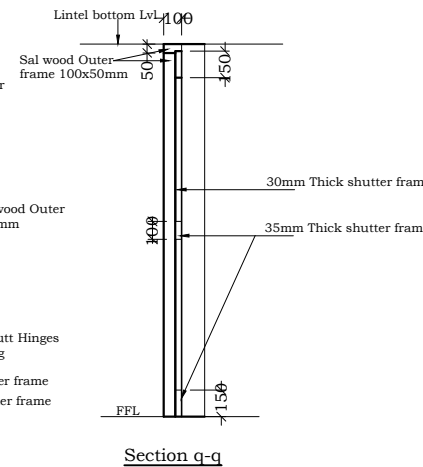

Section q-q

Note: For uPVC frame, sash and mullion extruded profiles minus 5% tolerance in dimension i.e. in depth & width of profile shall be acceptable. Fixed window / ventilator made of (small series) frame 47 x 50 mm & mullion 47 x 68 mm both having wall thickness of 1.9 ± 0.2 mm and single glazing bead of appropriate dimension. (Area upto 0.75 sqm.)

Note:-
Fixing aluminium work for doors with extruded built up standard tubular sections/ appropriate Z sections and other sections of approved make conforming to IS: 733 and IS: 1285, fixing with dash fasteners of required dia and size, including necessary filling up the gaps at junctions, i.e. at top, bottom and sides with required EPDM rubber/ neoprene gasket etc. Aluminium sections shall be smooth, rust free, straight, mitred and jointed mechanically wherever required including cleat angle, Aluminium snap beading for glazing / paneling, C.P. brass / stainless steel screws, all complete as per architectural drawings and the directions of Engineer-in-charge. (Glazing, paneling and dash fasteners to be paid for separately) :
Polyester powder coated aluminium (minimum thickness of polyester powder coating 50 micron)

Note :- The Specification mentioned in the tender should be followed for the wood, aluminium, grill and UPVC door etc..

Revisions

S.No	Rev.Date	Remarks	Sign	Check

Scale - NTS	Date - 29-08-2022
DC -	Dealt -
Checked-	Drawn by- Asa Sreelesh
Drg.No - 004	Job No.-

All Dimensions Are In Millimeters

Title :- JOINERY DETAILS


Name of work:- CB RSETI @ KOTTIYAM

Client Signature:-

Client :-
CANARA BANK,
RD Section, FI Wing,
HO Annexe, Gandhinagar,
Bangalore-560009


Architect Signature & Seal

Architect:-
Prima Arch
Head office
Convent Road
Cherthala
Ph: 0478-2820159
E-mail primaarch@gmail.com

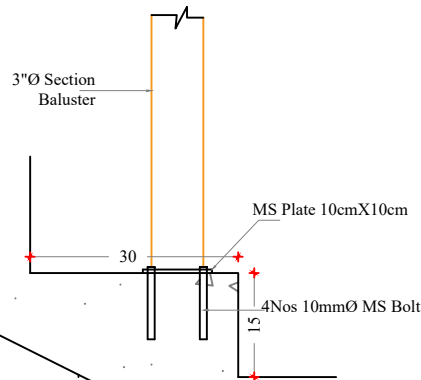


CROSS SECTION

BALUSTER FIXING DETAILS

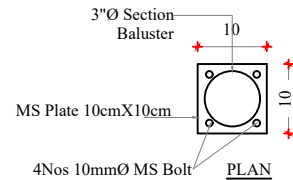


PLAN

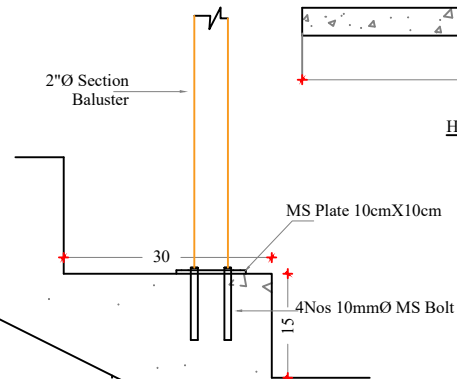


CROSS SECTION

HANDRAIL DETAILS

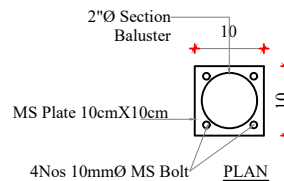

PLAN

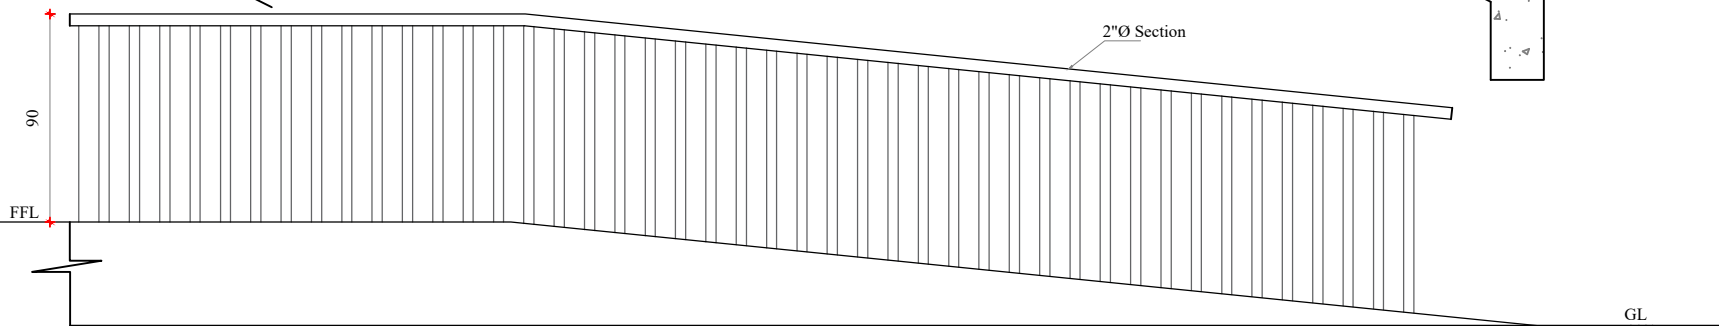

RAILING OF RAMP

Note :-
Providing and fixing stainless steel (Grade 304) railing made of Hollow tubes, channels, plates etc., including welding, grinding, buffing, polishing and making curvature (wherever required) and fitting the same with necessary stainless steel nuts and bolts complete, i/c fixing the railing with necessary accessories & stainless steel dash fasteners, stainless steel bolts etc., of required size, on the top of the floor or the side of waist slab with suitable arrangement as per approval of Engineer-in-charge

Revisions

S.No.	Rev : Date	Remarks	Sign	Check

Scale : NTS	Date : 21-08-2022
DC :	Dealt :
Checked :	Drawn By : Asa Sreelesh
Drawing No: 005	Job no :

ALL DIMENSIONS ARE IN CENTIMETERS

Title : MS HANDRAIL DETAILS

Name of work: CBRSETI KOLLAM

Clients Signature


Client : CANARA BANK,
RD Section, FI Wing,
HO Annexe, Gandhinagar,
Bangalore-560009

Architects Signature & seal


Architect :

Prima Arch


Head office
(Architect, CA-84 8733, REG Valuer-F-3047)
359 - E, 1st Floor
Convent Road, Chertala - 688 524
PH - 0478 - 2820159
E-mail primaarch@gmail.com

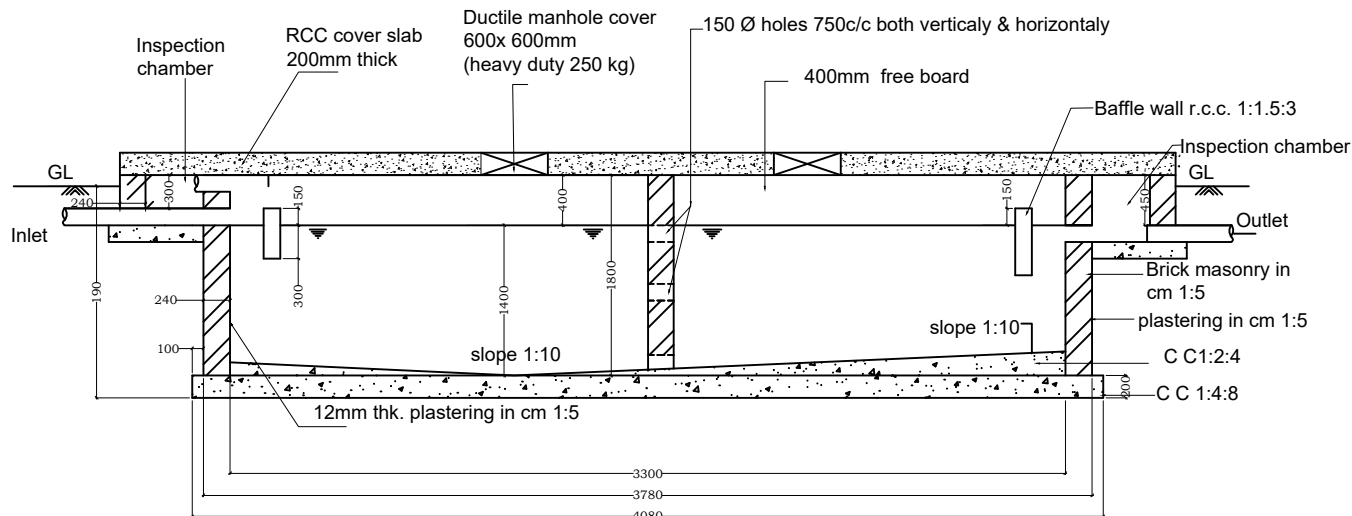


Section

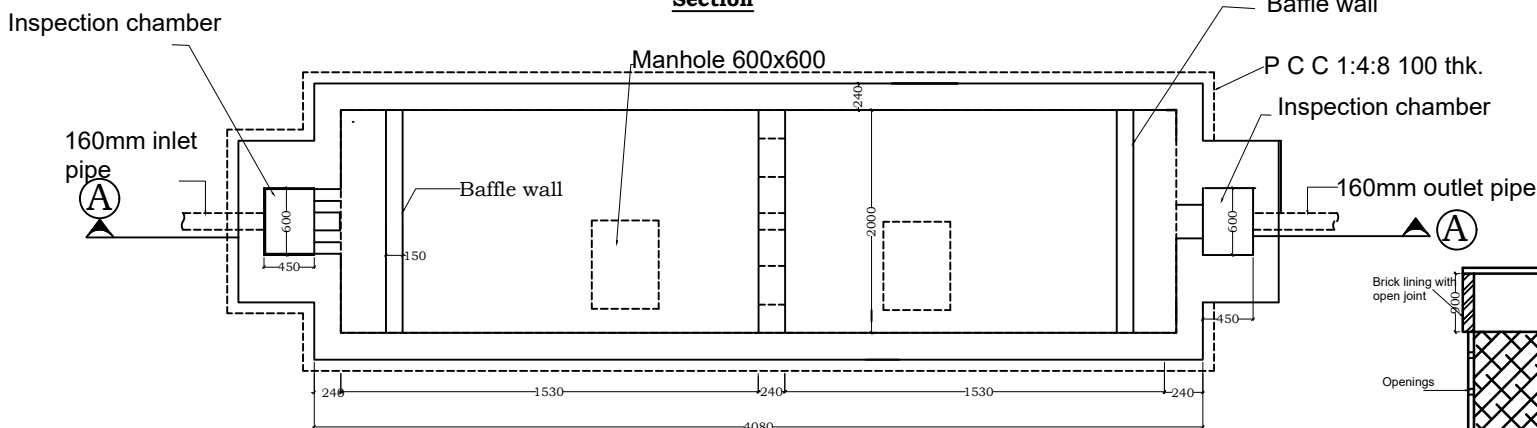


Plan of Septic tank -12500 Liter Capacity

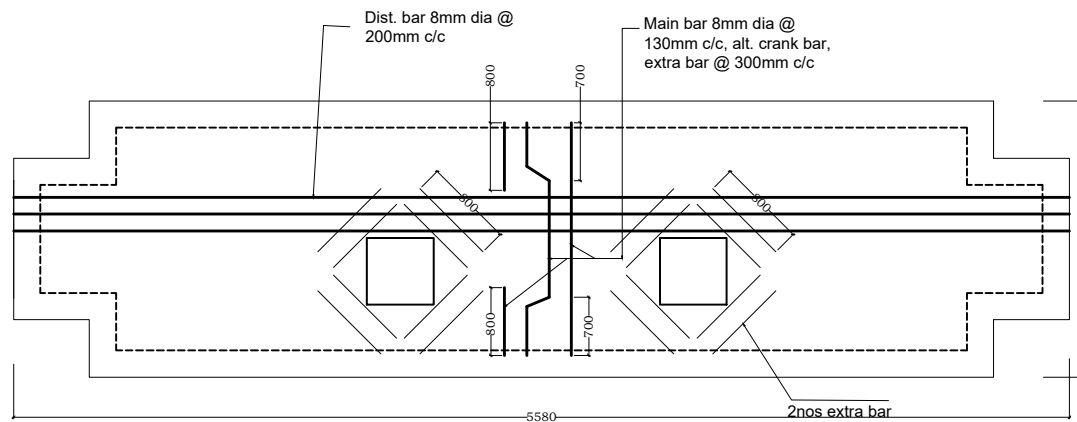

Cover Slab Detail Of Septic Tank

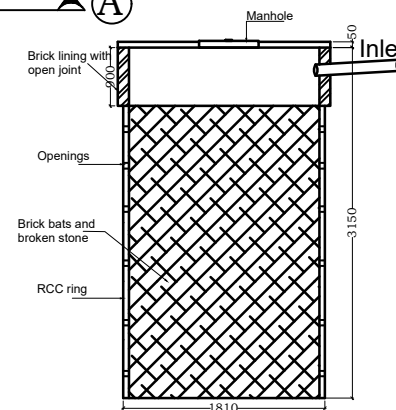

SECTION

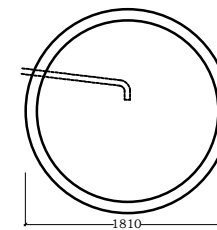

PLAN

SOAK PIT DETAILS

Revisions

S.No	Rev : Date	Remarks	Sign	Check

Scale : NTS	Date : 21-08-22
DC :	Dealt :
Checked : GJ	Drawn By : Asa Sreelesh
Drawing No : 006	Job no :

All Dimensions are in Millimetre

Title :

Name of work:

SEPTIC TANK & SOAK PIT DETAIL

Clients Signature

CB RSETI @ KOTTIYAM

Client :

CANARA BANK,
RD Section, FI Wing,
HO Annexe, Gandinagar,
Bangalore-560009

Architects Signature & seal :-

Architect

Prima Arch

Head office

(Architect, CA-84 8733, REG Valuer-F-3047)
359 - E, 1st Floor
Convent Road, Cherthala - 688 524
PH - 0478 - 2820159
E-mail primaarch@gmail.com